



TAL-CO SUPPLEMENTAL INSTRUCTION #23			
Project Name:	RW TOMLINSON - NEW HEAD OFFICE		
Project Location:	100 City Gate Drive, Ottawa, Ontario		
ARCH. SI #:	ASK #'s 50, 51, 52	Issued By:	Chris Simpson
STRUC. SI #:	N/A	Date Issued:	December 21, 2016
MECH. SI #:	N/A	Revision #:	N/A
ELEC. SI #:	N/A	Revision Date:	N/A

Supplemental Instructions are issued by the Construction Manager to record a clarification or revision to the previously issued Contact Documentation as reflected by the attached information prepared by the identified Professionals.

The Construction Manager shall review the Supplemental Instruction and the attached information and issue to the affected Trade Contractors identifying the following course of action by the Trade Contractor.

Notify TAL-CO within 5 days of receipt, if the attached documents will require a change to Contract Price or Schedule.


Title: Details of water wall in main atrium (Grid C between 2 & 3)

Reference: Architectural - Issued for Construction Drawings dated 11-Nov-16

Attachments:

- ASK-50
- ASK-51
- ASK-52

Reason: Clarification of details and assemblies at the water wall in the main atrium (Grid C between 2 & 3). Structural/ Mechanical details yet to be confirmed when shop drawings are available.

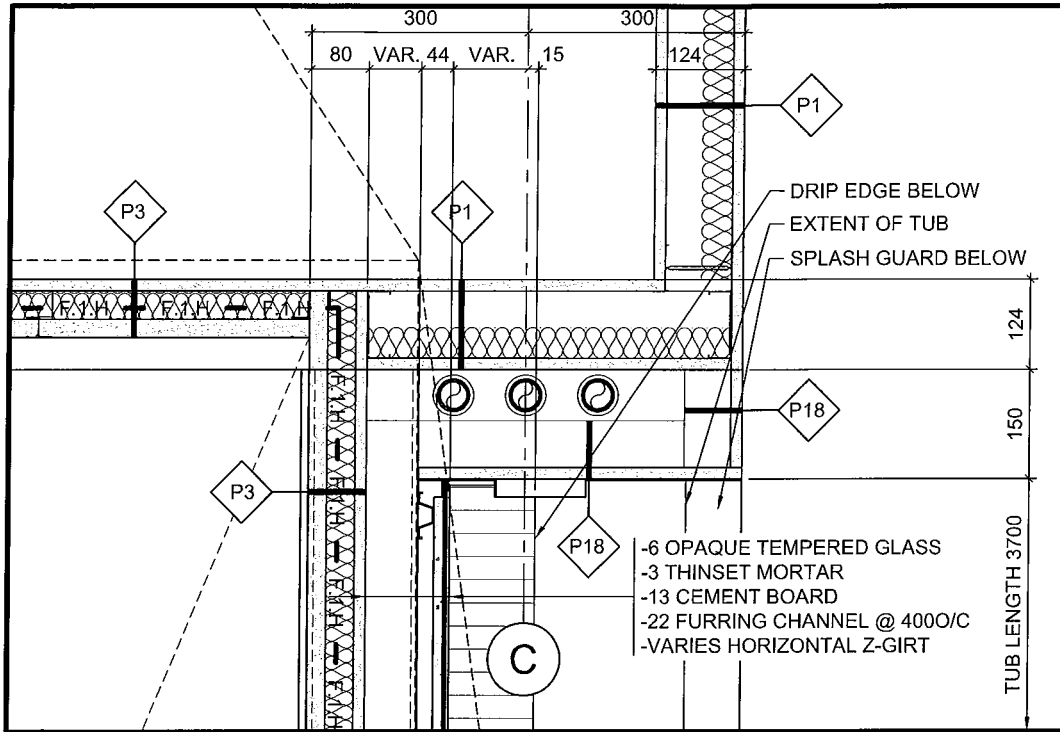

20
503

TYPICAL WATER FEATURE DETAIL

SCALE = 1:10



THE ANNEX/466 CECLES ST. OTTAWA ON K1R 6E3
613.567.7858 PHONE / 613.567.7528 FAX
csarchitect.com



PROJECT:
TOMLINSON NEW BUILDING

DRAWING TITLE:
REFERENCE NEW DET. AS INDICATED



DATE: 2016/11/28

SCALE: AS INDICATED

DRAWN BY: JK

JOB No: 574-15

DRAWING No:
ASK-50

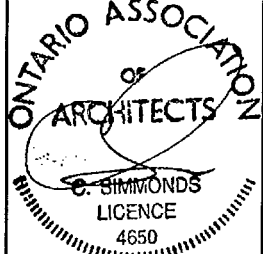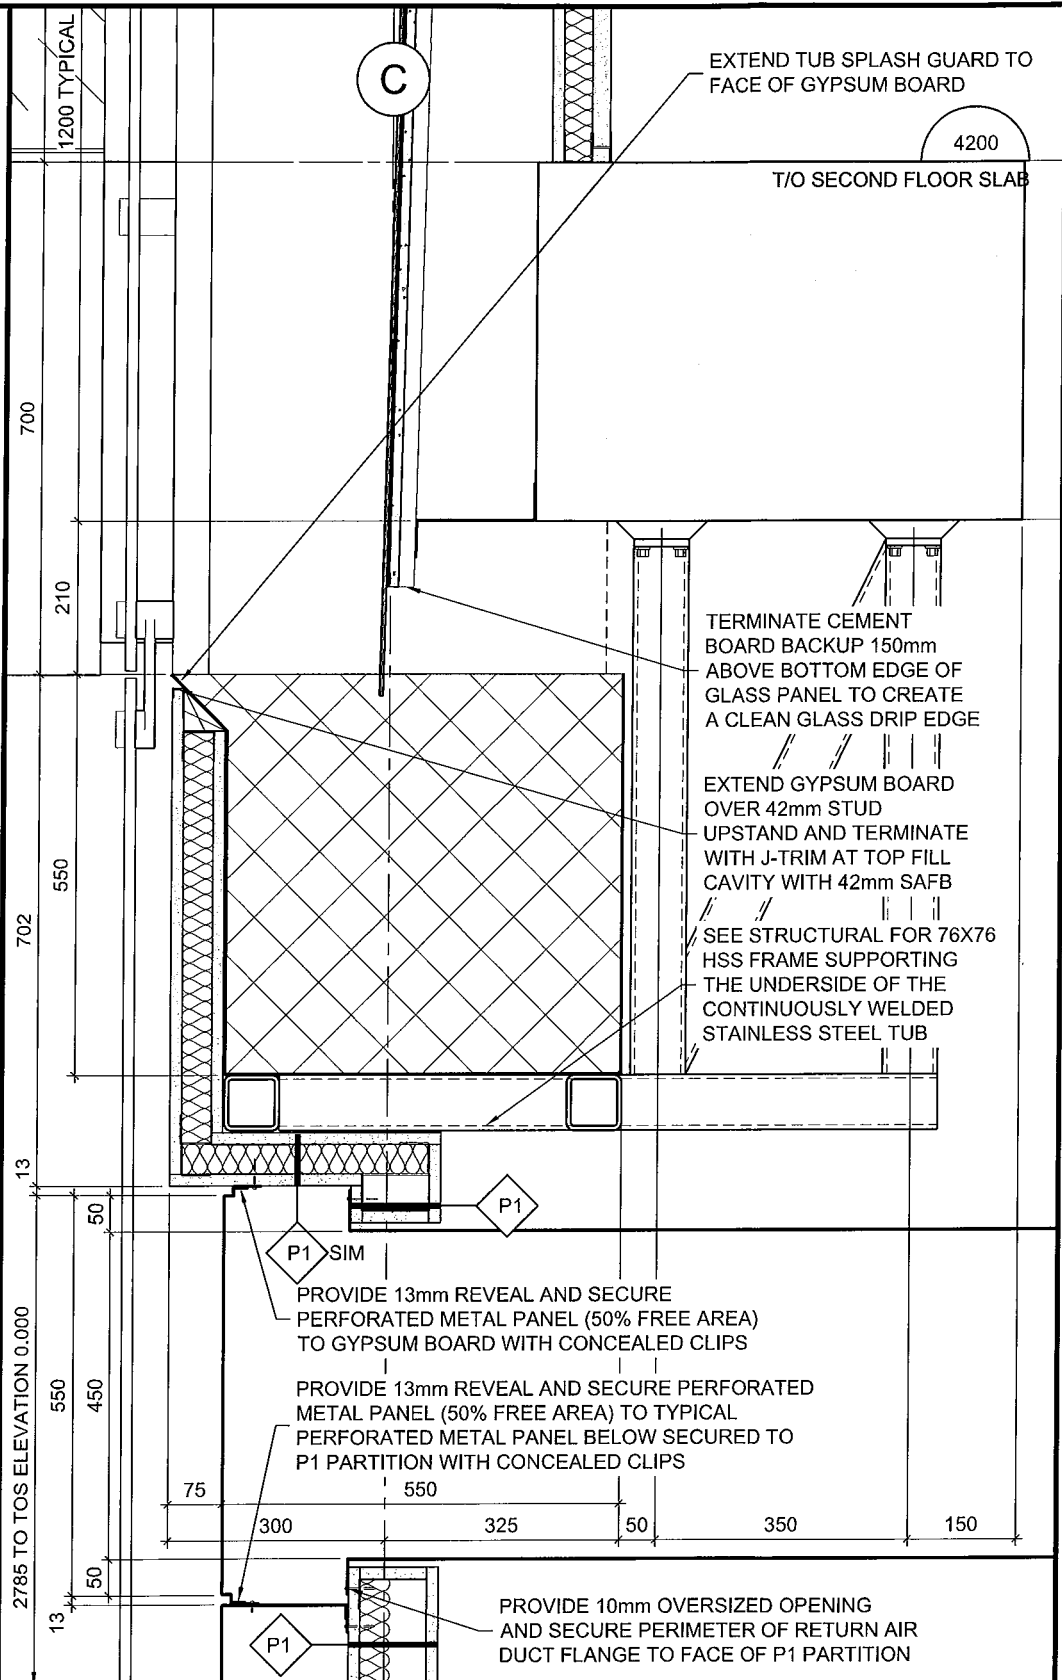


THE ANNEX / #ECCLLES ST. OTTAWA ON K1R 6S5
 613.567.7858 PHONE / 613.567.7528 FAX
 csarchitect.com

PROJECT:
TOMLINSON NEW BUILDING

DRAWING TITLE:
REFERENCE PART. NEW DETAIL 2/A604

DATE: 2016/12/06
 SCALE: 1:10
 DRAWN BY: JK
 JOB No: 574-15

DRAWING No:
ASK-51

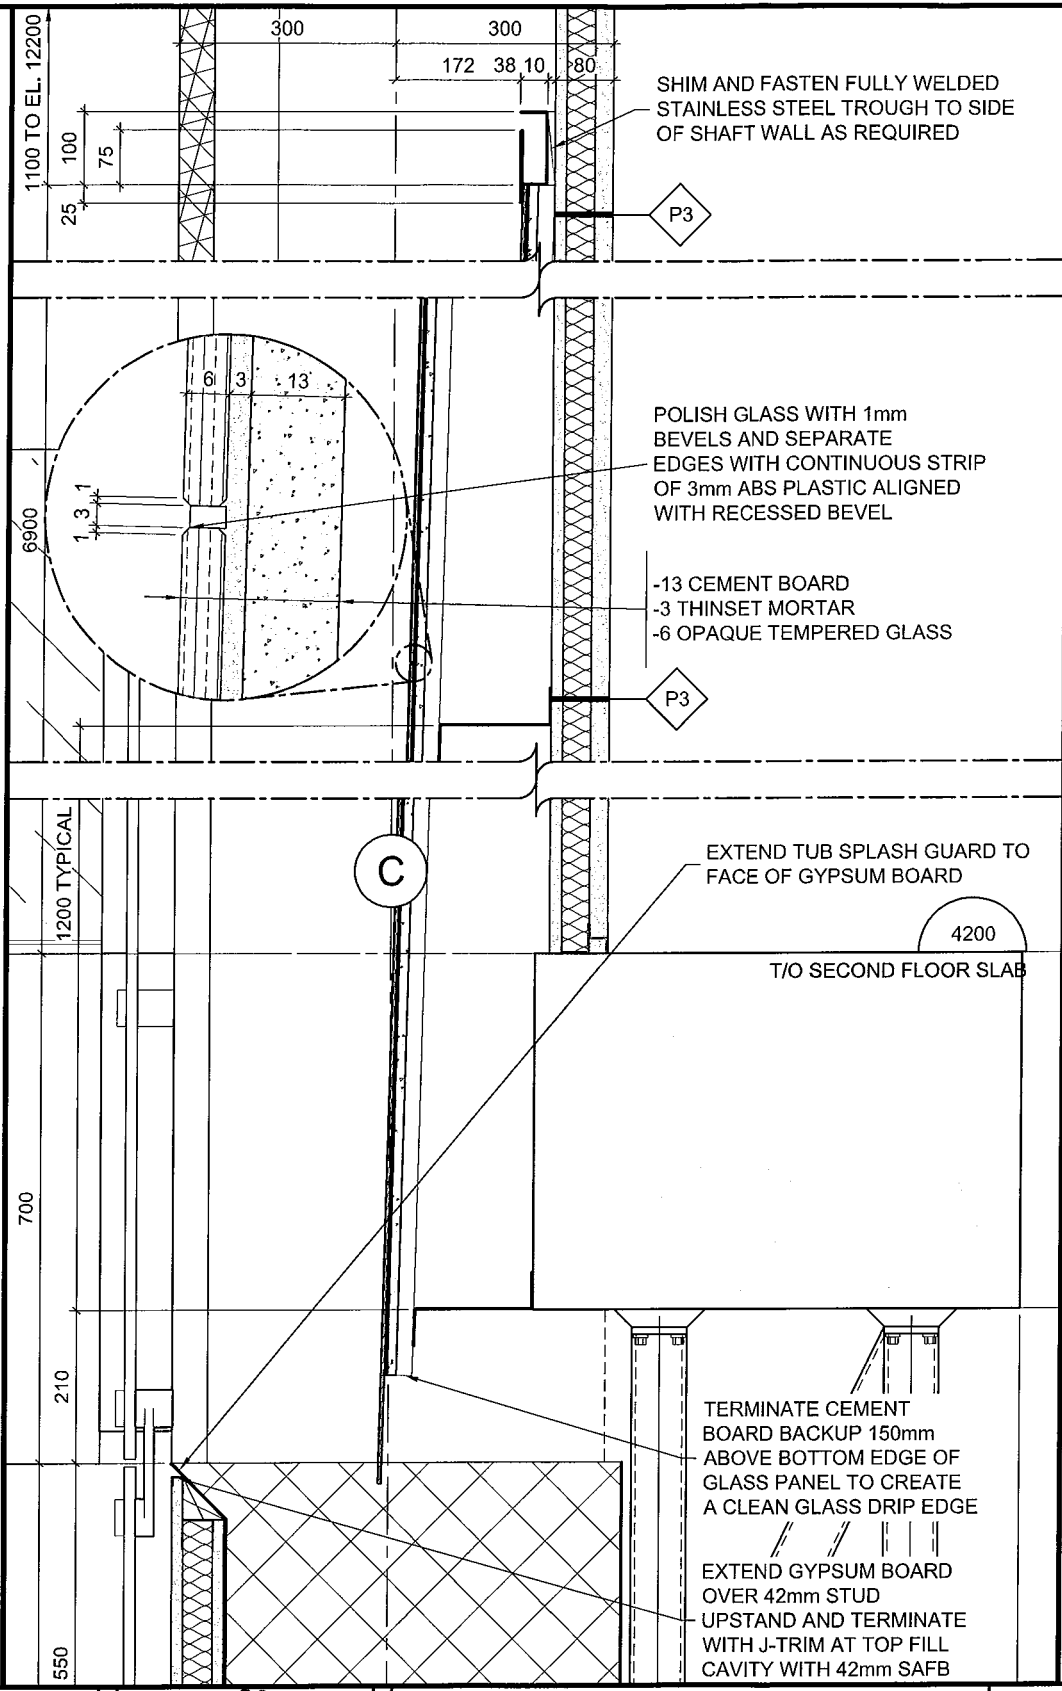

THE ANNEX / BECCLES ST. OTTAWA ON K1R 6S5
613.567.7688 PHONE / 613.567.7525 FAX
esarchitect.com



PROJECT:
TOMLINSON NEW BUILDING

DRAWING TITLE:
REFERENCE PART. NEW DETAIL 2/A604

DATE: 2016/12/06

SCALE: 1:10

DRAWN BY: JK

JOB No: 574-15

DRAWING No:
ASK-52