



TAL-CO SUPPLEMENTAL INSTRUCTION #26			
Project Name:	RW TOMLINSON - NEW HEAD OFFICE		
Project Location:	100 City Gate Drive, Ottawa, Ontario		
ARCH. SI #:	ASK # 65	Issued By:	Chris Simpson
STRUC. SI #:	SSI #15 R1	Date Issued:	February 13, 2017
MECH. SI #:	N/A	Revision #:	N/A
ELEC. SI #:	N/A	Revision Date:	N/A

Supplemental Instructions are issued by the Construction Manager to record a clarification or revision to the previously issued Contact Documentation as reflected by the attached information prepared by the identified Professionals.

The Construction Manager shall review the Supplemental Instruction and the attached information and issue to the affected Trade Contractors identifying the following course of action by the Trade Contractor.

Notify TAL-CO within 5 days of receipt, if the attached documents will require a change to Contract Price or Schedule.

 

**Title:** Detailing of retaining wall near Grid 1 between G and J.

**Reference:** Architectural Construction Update Drawing (Feb. 2nd, 2017) A-001, A-003, A-101  
Structural Drawings, Detail R on S-004


**Attachments:**  
ASK-65  
SSI-15 R1

**Description of the Work:** This retaining wall has been detailed to add a recessed niche to house the Enbridge Gas meter.

**Reason:** Recessing the gas meter will make it less obtrusive and more esthetically appealing.

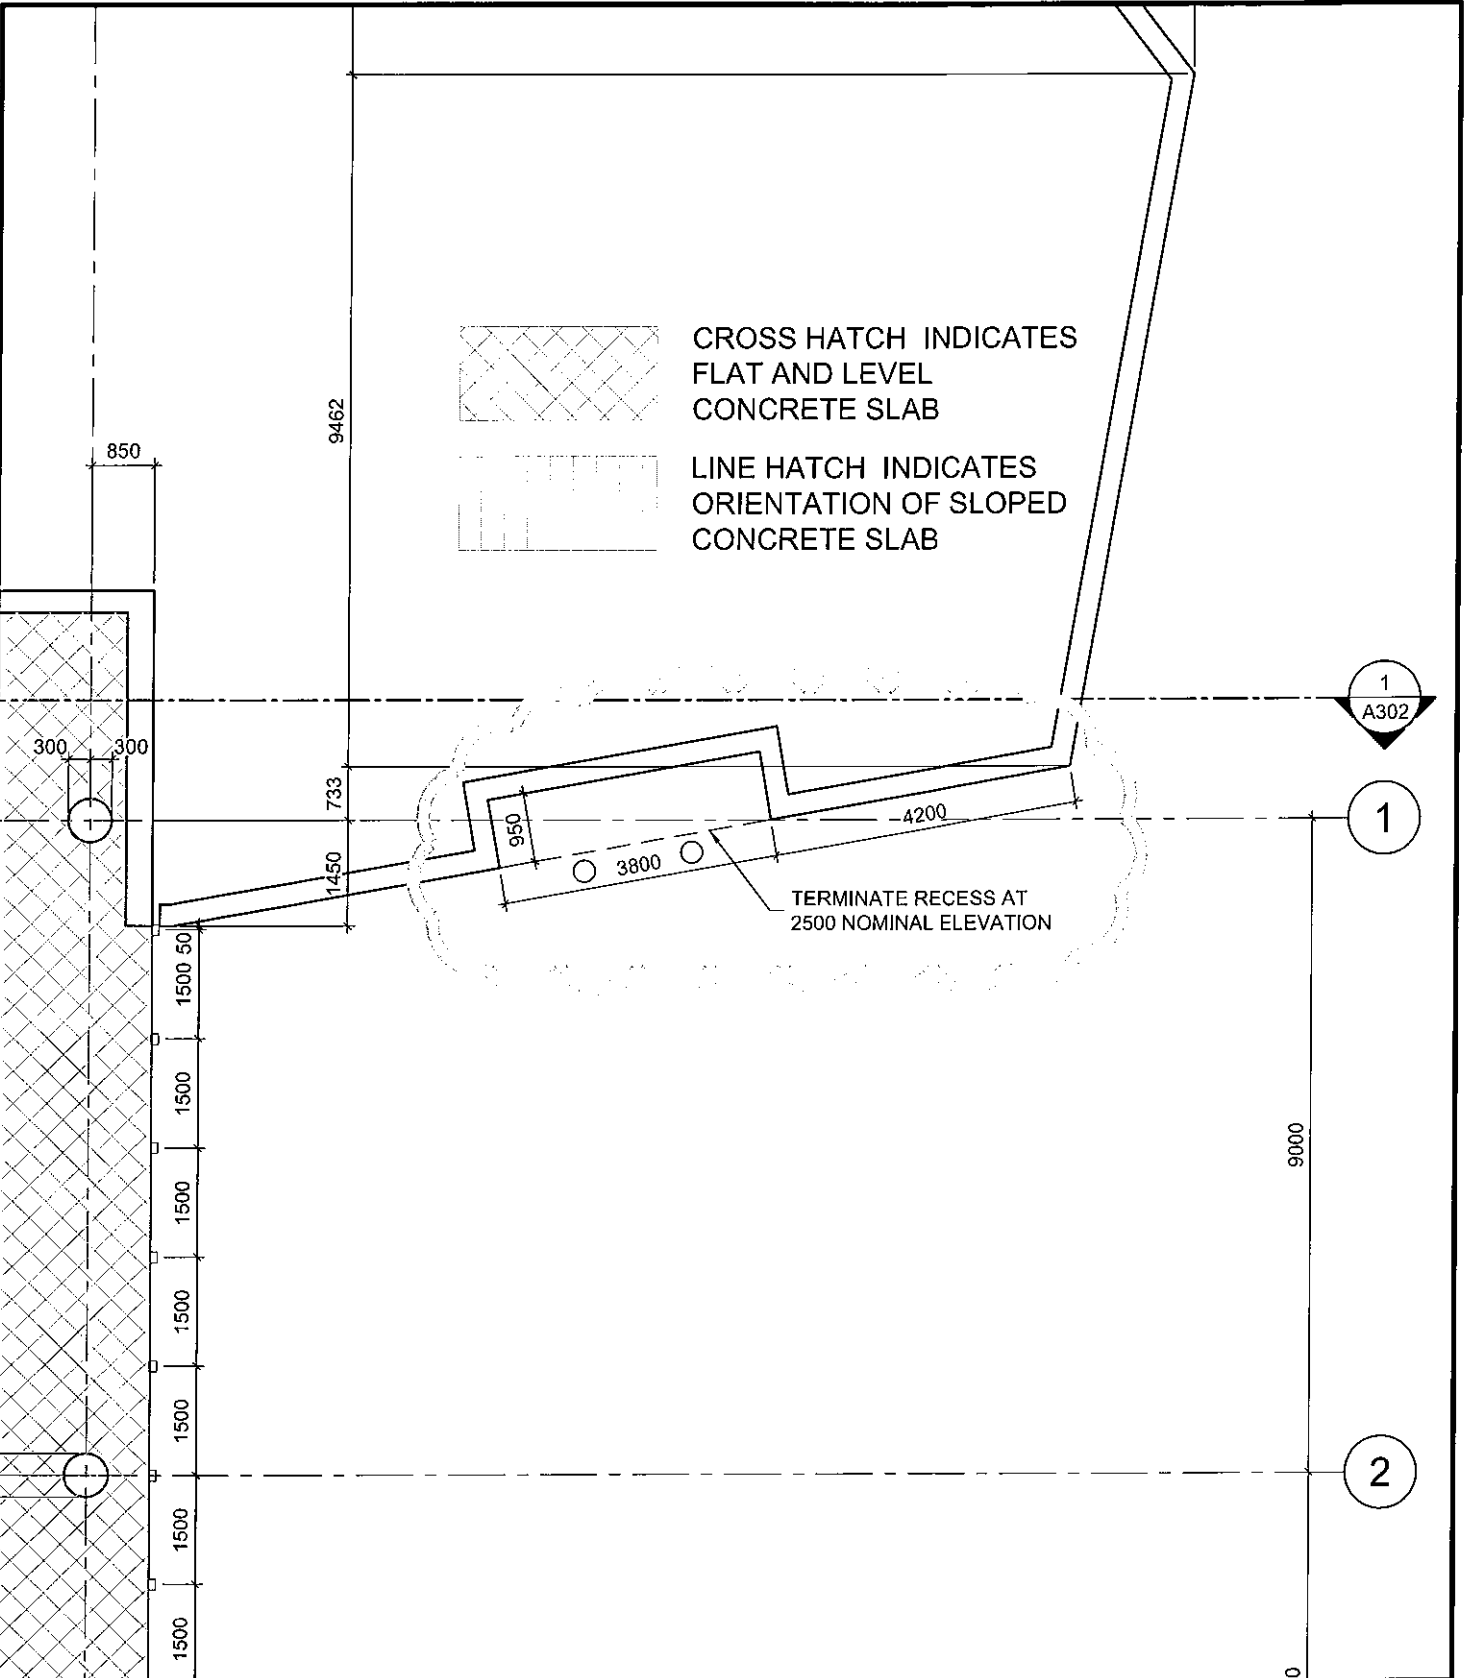

 CROSS HATCH INDICATES  
FLAT AND LEVEL  
CONCRETE SLAB




LINE HATCH INDICATES  
ORIENTATION OF SLOPED  
CONCRETE SLAB

TERMINATE RECESS AT  
2500 NOMINAL ELEVATION



THE ANNEX / BECCLES ST. OTTAWA ON K1R 6S1  
613.567.7888 PHONE / 613.567.7824 FAX  
csarchitect.com

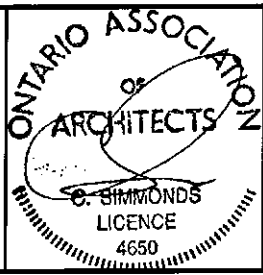

PROJECT: TOMLINSON NEW BUILDING	DATE: 2017/01/23
	SCALE: 1:100
	DRAWN BY: JK
DRAWING TITLE: REFERENCE PART OF 1/A111	JOB No: 574-15
	DRAWING No: <b>ASK-65</b>

# STRUCTURAL SITE INSTRUCTION



Cleland Jardine Engineering Ltd., 580 Terry Fox Drive, Suite 200, Kanata, Ontario, K2L 4B9, FAX (613) 591-1703, Tel. (613) 591-1533

TO: TALCO Building Innovations DATE: Feb.01, 2016

ATTENTION: Chris Simpson EMAIL: csimpson@tal-co.com

PROJECT: Tomlinson – New Building PROJECT No.: 15-0179

ISSUED BY: Nas Torabi PAGES (Incl this one): 2

STRUCTURAL SITE INSTRUCTION No.: 015R01

**Affected Drawings:** S100

**References:** Ask-65  
Retaining wall footing along G/L 1.


**Information to be Clarified:**  
Contractor is to refer to attached sketch for retaining wall footings.



CLELAND JARDINE

Project	TOMLINSON	By	BJ	Job No.	15.0179
Description	RETAINING WALL @ NOTCH	Date	JAN 31/17	Sheet No. of	2

590 Terry Fox Drive, Suite 200, Kanata, ON K2L 4B9 Tel: (613) 591-1533 Fax: (613) 591-1703

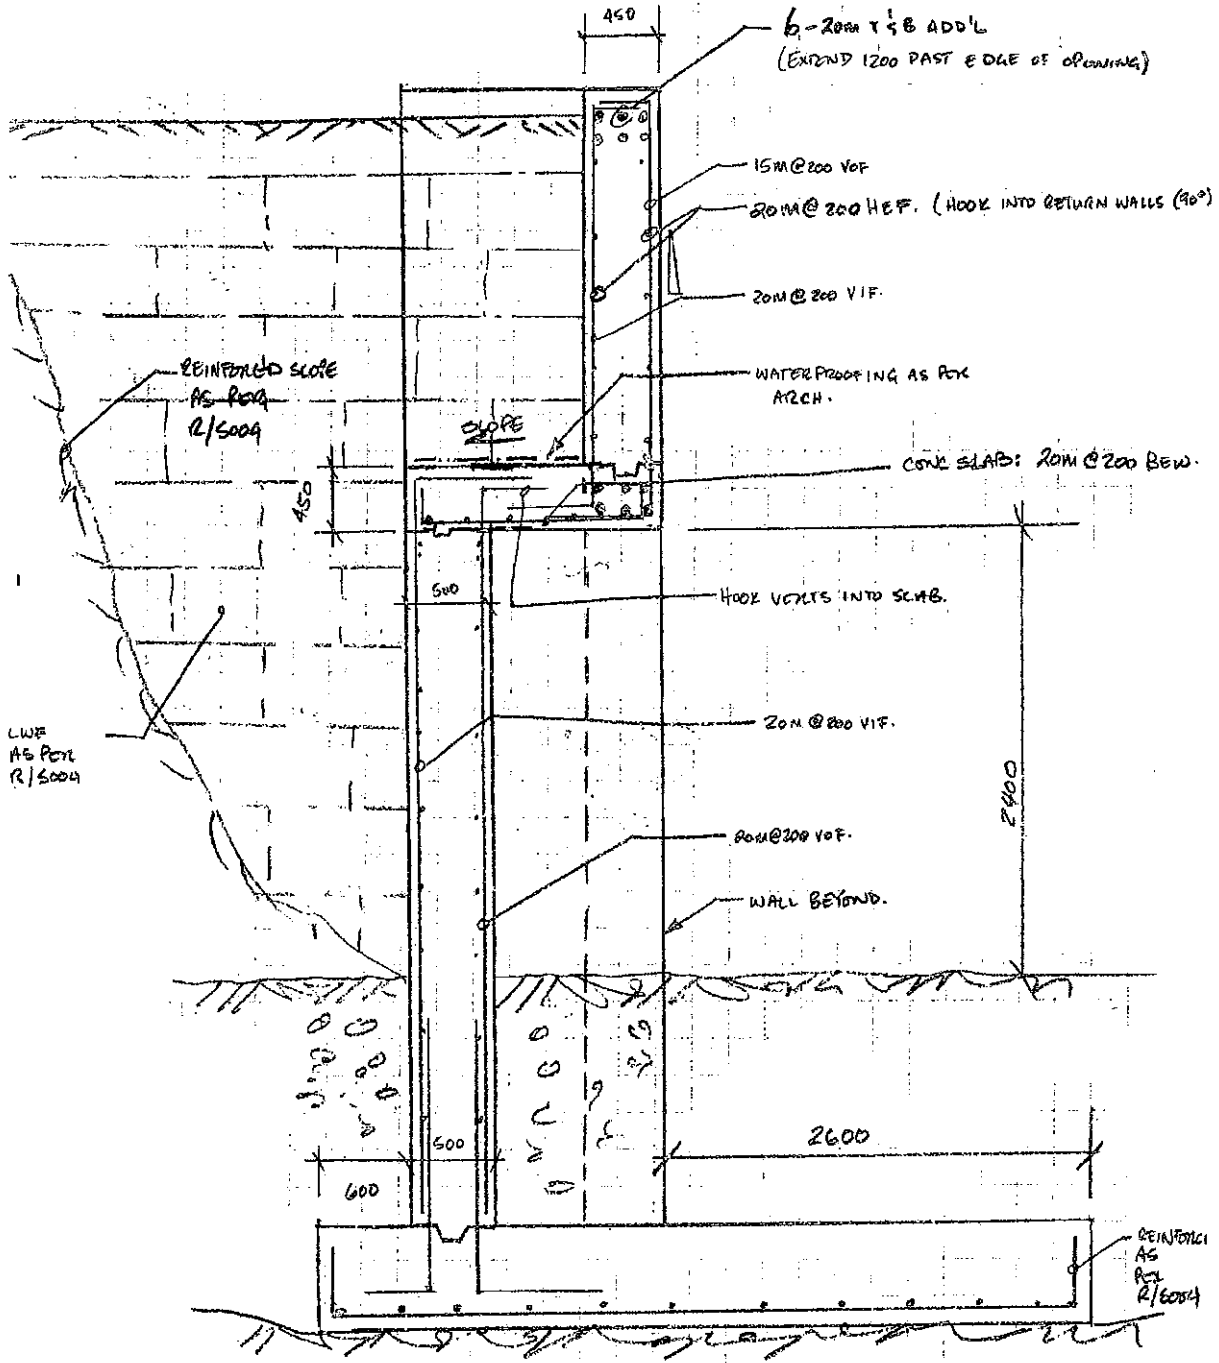

6  
6004

SECTION: RETAINING WALL @ GAS METER NOTCH.