



TAL-CO SUPPLEMENTAL INSTRUCTION #13			
Project Name:	RW TOMLINSON - NEW HEAD OFFICE		
Project Location:	100 CitiGate Drive, Ottawa, Ontario		
ARCH. SI #:	ASK #13, 14, 15	Issued By:	Chris Simpson
STRUC. SI #:	N/A	Date Issued:	April 12, 2017
MECH. SI #:	Vipond Revised Gr. Flr.	Revision #:	N/A
ELEC. SI #:	N/A	Revision Date:	N/A

Supplemental Instructions are issued by the Construction Manager to record a clarification or revision to the previously issued Contact Documentation as reflected by the attached information prepared by the identified Professionals.

The Construction Manager shall review the Supplemental Instruction and the attached information and issue to the affected Trade Contractors identifying the following course of action by the Trade Contractor.

Notify Tal-Co within 5 days of receipt, if the attached documents will require a change to Contract Price or Schedule.

Title: Re-routing of 4" sprinkler main through vestibule parallel to Grid 1, see ASK's #13 and #14, as attached. Revised height of interior vestibule framing/ glazing (AGS-1) to suit structure, see ASK #15, as attached.

Reference: Architectural plans and sections, sprinkler layout drawings.


Attachments:

- ASK-13
- ASK-14
- ASK-15
- Vipond - Revised Ground Floor Layout Drawing

Description of the Work:

- 1.) Re-route 4" sprinkler main as shown.
- 2.) Modify interior vestibule framing and glazing as shown.

Reason: Original routing for sprinkler pipe through atrium was unfeasible, revised routing now confirmed on sprinkler layout drawings. Vestibule glazing dimensions revised to suit clearance to underside of slab.

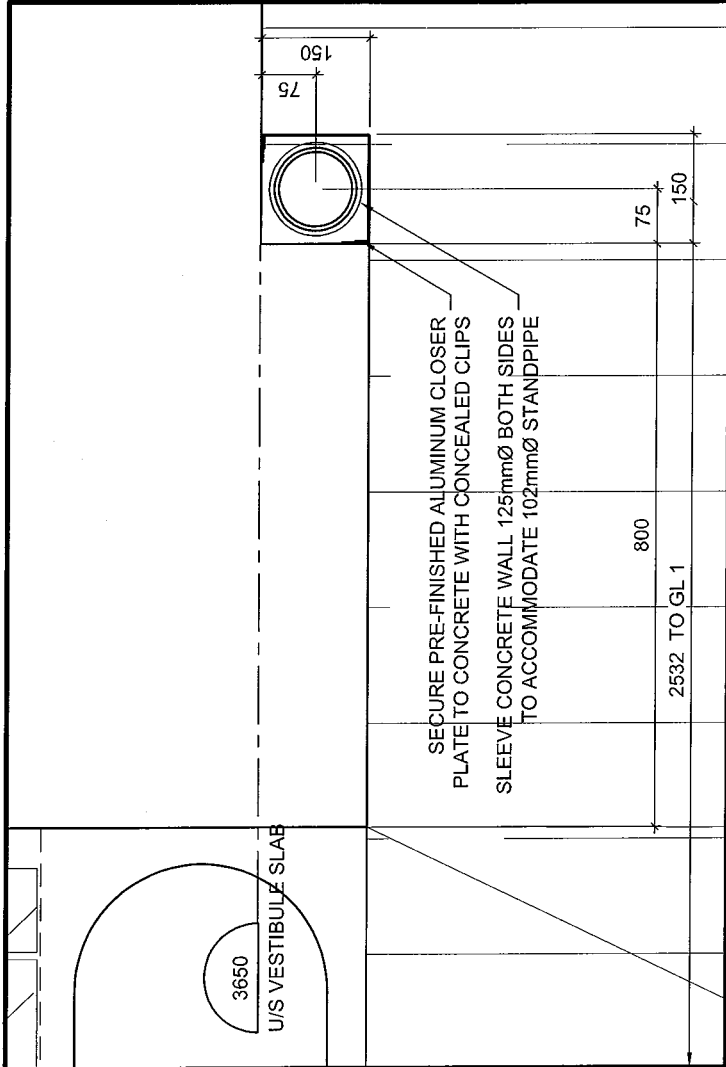


8 HORIZONTAL STANDPIPE CHASE DETAIL

SCALE = 1:10

8
A604

DATE:	2016/10/12
SCALE:	AS NOTED
DRAWN BY:	JK
JOB No:	574-15
DRAWING No:	ASK-13

PROJECT:	TOMLINSON NEW BUILDING
DRAWING TITLE:	REFERENCE NEW DETAIL AS NOTED

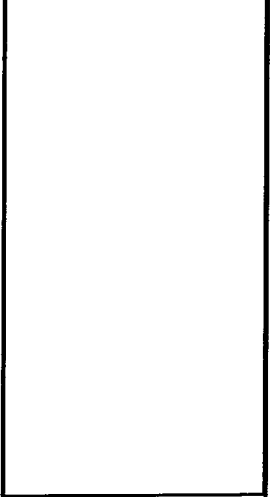


**Christopher
Simmonds
Architect**

TURANNEX / RECULES ST. OTTAWA ON K1R 6S3
513.567.7888 PHONE / 413.567.7528 FAX
csw@architect.com

**ONTARIO ASSOCIATION
of
ARCHITECTS**


**CHRISTOPHER SIMMONDS
LICENCE
4650**

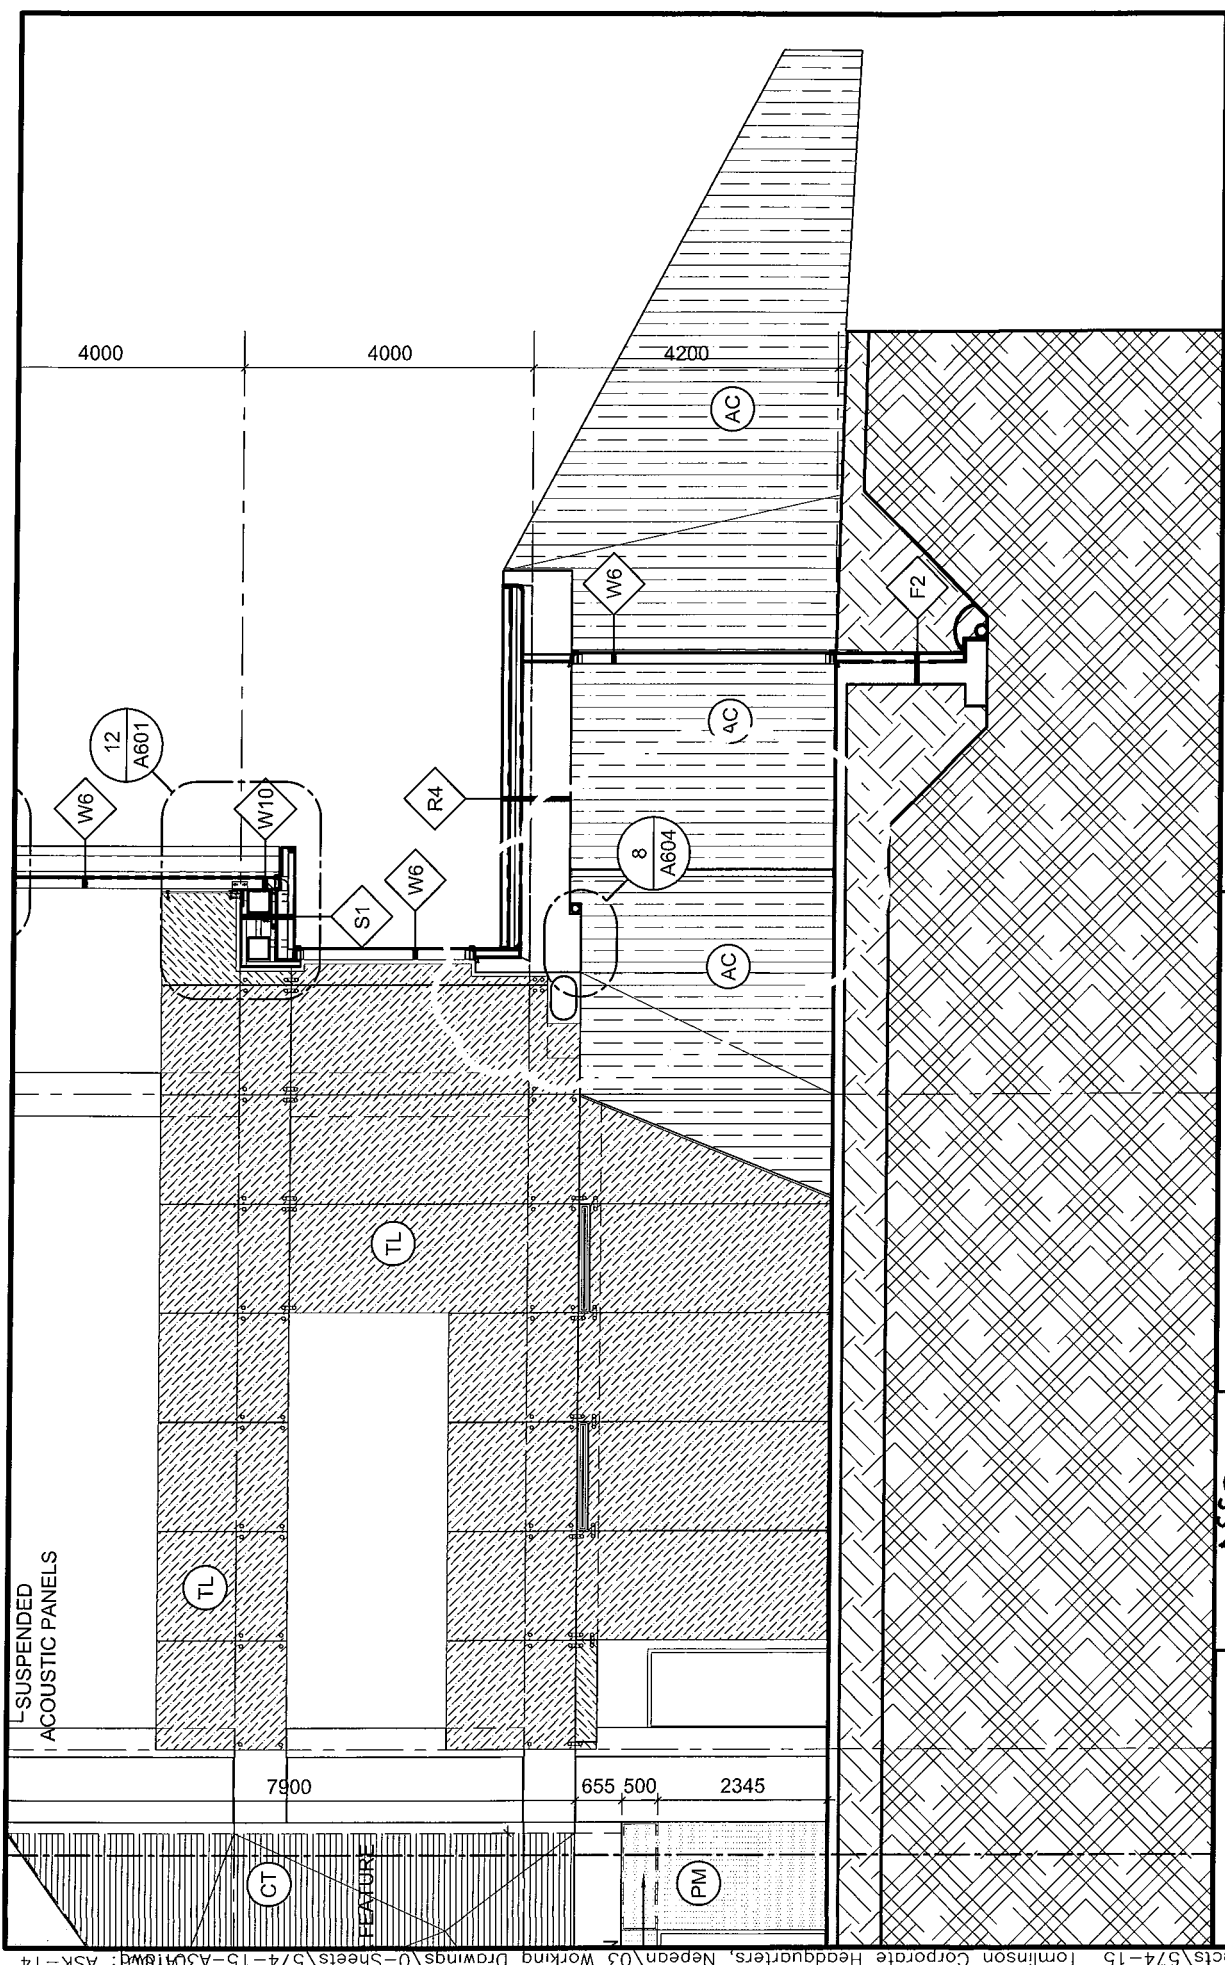

DATE: 2016/10/12
 SCALE: 1:100
 DRAWN BY: JK
 JOB No: 574-15
 DRAWING No: ASK-14

PROJECT: TOMLINSON NEW BUILDING
 DRAWING TITLE: REFERENCE PART 3/A301

Christopher Simmonds Architect
 4650
 LICENCE

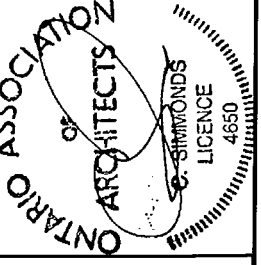

TURANNEK / PECULES ST. OTTAWA ON K1R4S3
 813.567.7888 PHONE / 813.567.7528 FAX
 csaarchitect.com

