


Note: See Enlarged Pool Plan on Drawing A-11

FLOOR PLAN LEGEND - DEMOLITION:

- INDICATES PORTION OF EXISTING BUILDING WHICH IS OUTSIDE THE WORK AREA OF THIS CONTRACT UNLESS NOTED OTHERWISE.
- DEMOLITION NOTE
- ROOM NAME INDICATES EXISTING ROOM NUMBER. SEE ALSO SCOPE OF WORK FORMS IN SPECIFICATION SECTION 05000
- INDICATES WALL TO BE DEMOLISHED
- INDICATES EXISTING WALL TO REMAIN
- EXISTING DOOR TO BE DEMOLISHED. REFER TO DOOR SCHEDULE.
- EXISTING DOOR TO REMAIN. REFER TO DOOR SCHEDULE.

FLOOR PLAN DEMOLITION NOTES:

- D1 REMOVE EXISTING DOOR AND FRAME.
- D2 REMOVED EXISTING WINDOW / FRAME
- D3 REMOVE EXISTING WALL
- D4 REMOVE EXISTING FLOORING AND BASE.
- D5 REMOVE EXISTING MILLWORK
- D6 EXISTING FLOORING TO REMAIN.
- D7 REMOVE EXISTING ELECTRICAL PANEL.
- D8 REMOVE WALLS FROM AROUND EXISTING EXHAUST DUCT, RETAIN DUCT
- D9 REMOVE EXISTING DRY DUCT RELOCATE AS PER MECHANICAL PLAN
- D10 REMOVE EXISTING EXTERIOR BRICK
- D11 REMOVE EXISTING CONCRETE BLOCK (EAST OF, BELOW WINDOW)

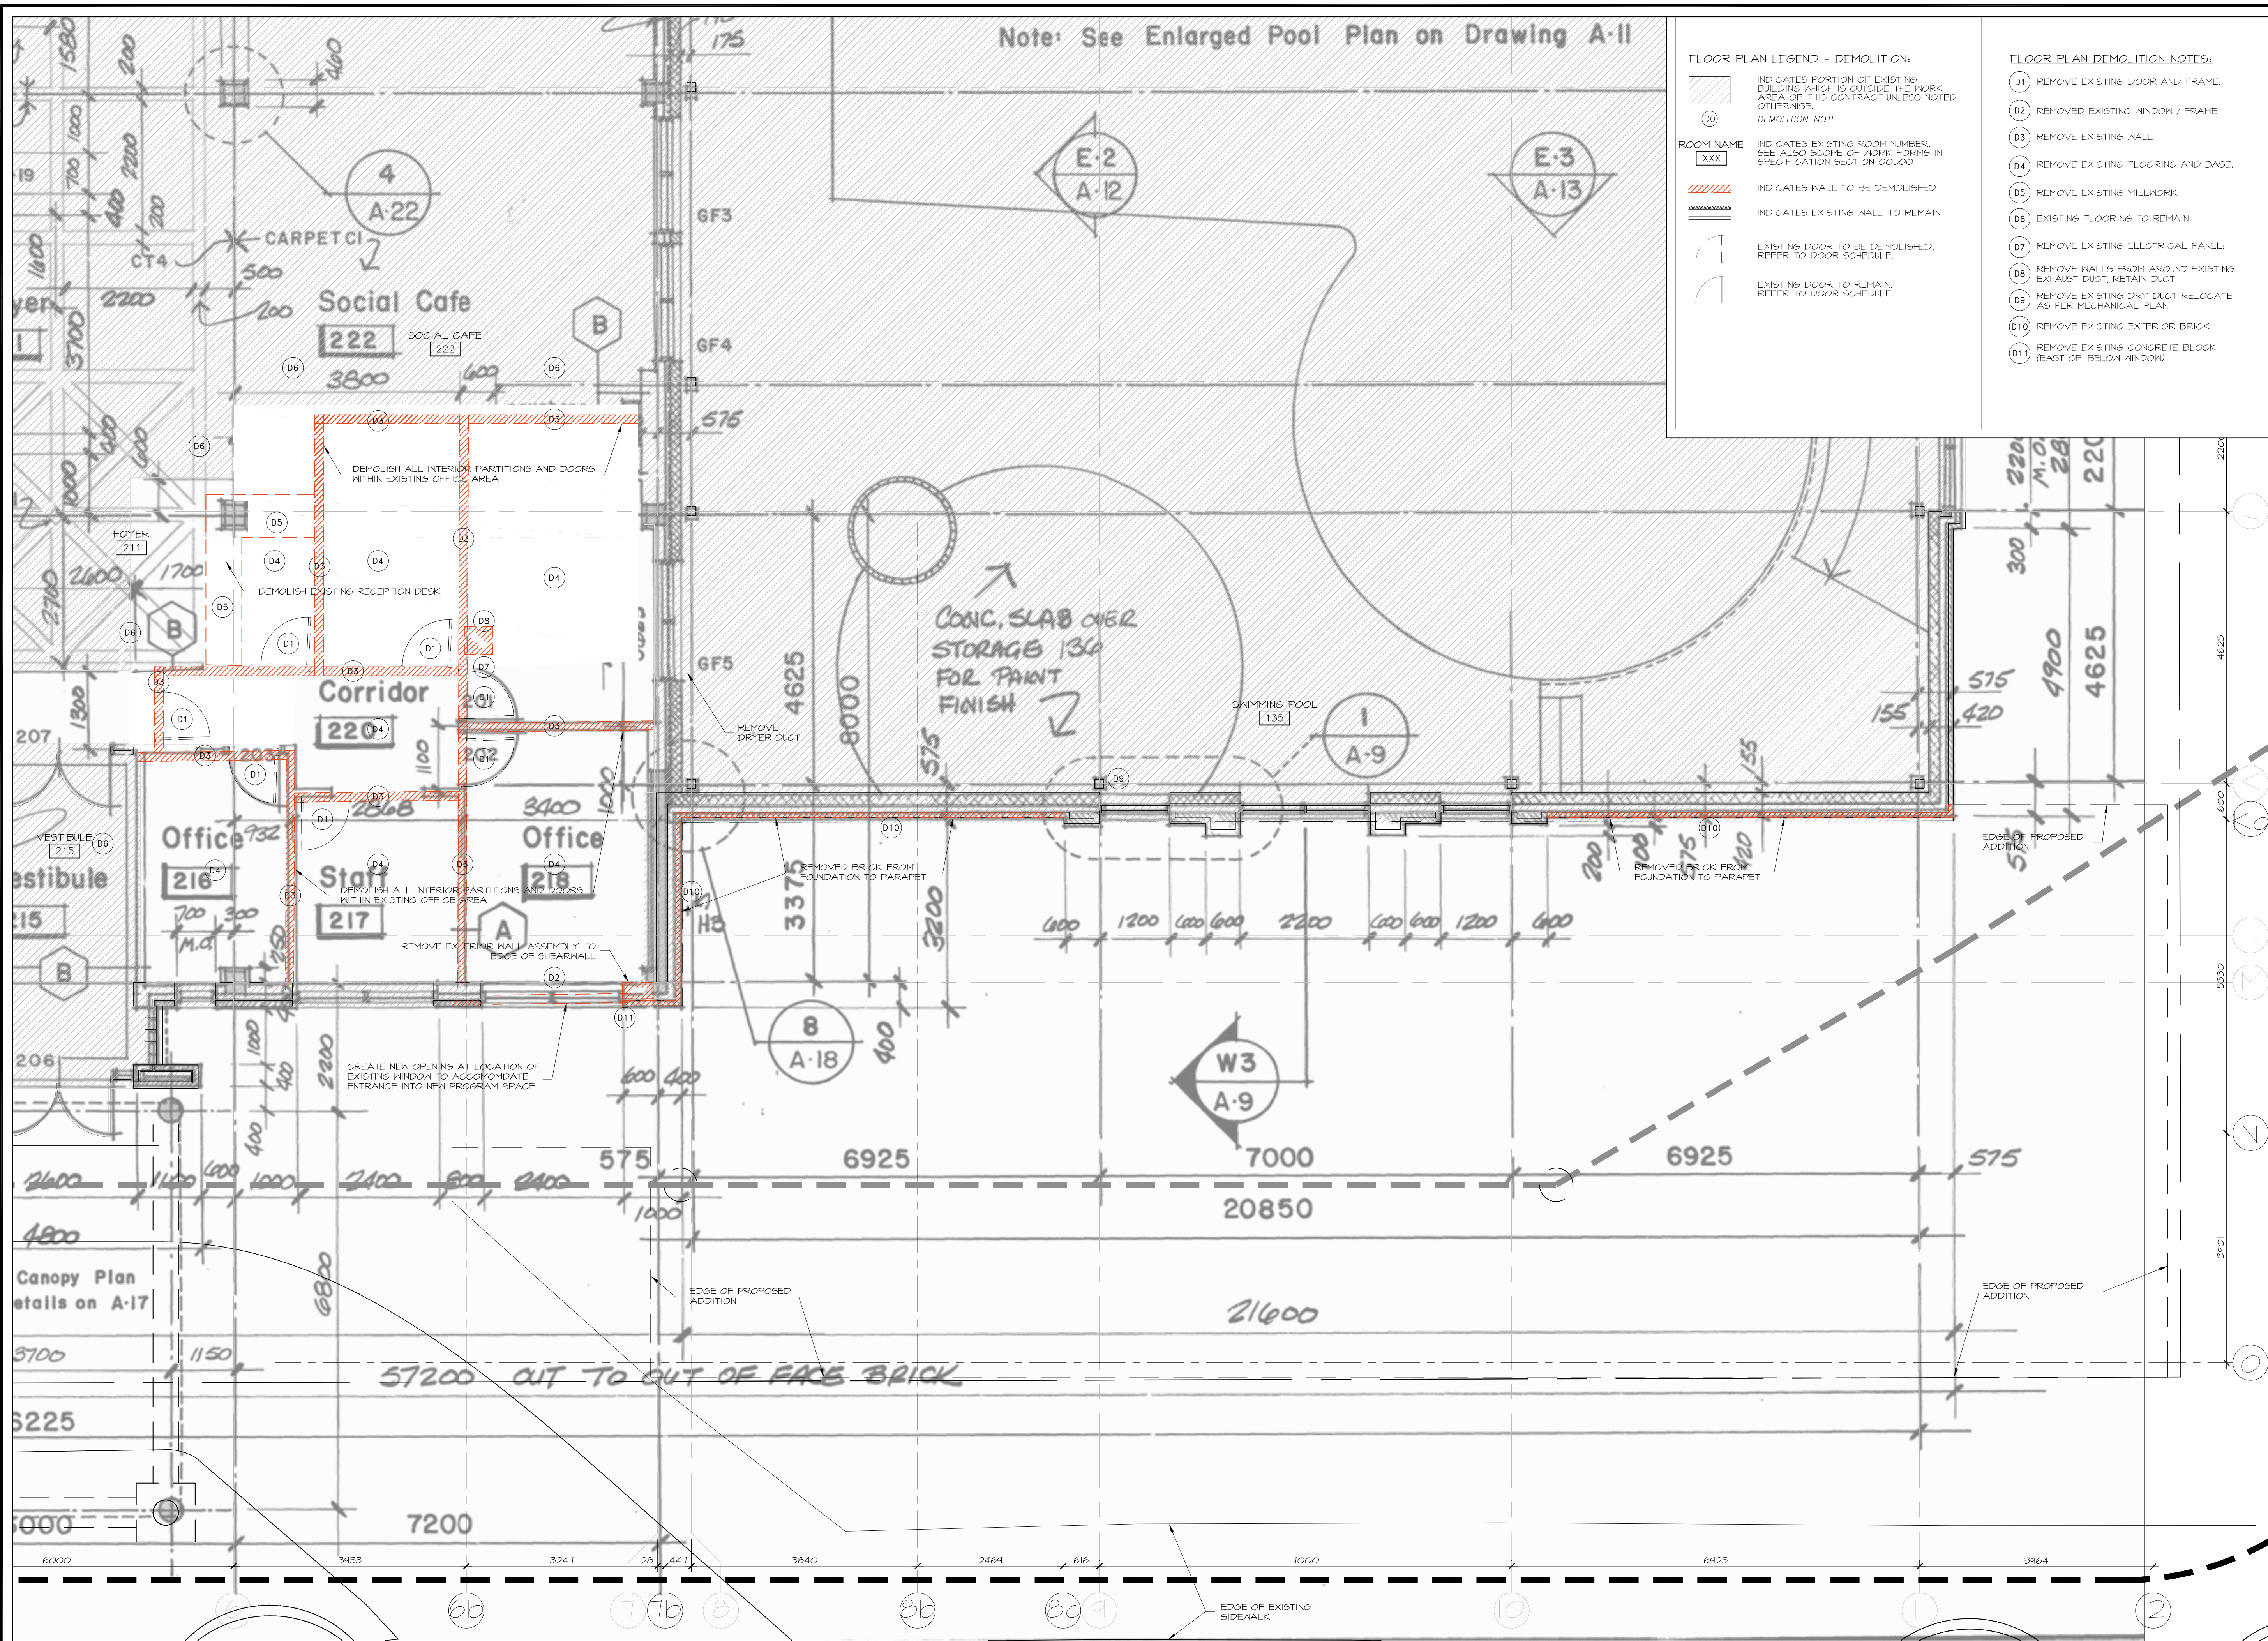

**Hobin Architecture Incorporated**  
 63 Parnilla Street  
 Ottawa, Ontario  
 Canada K1S 3K7  
 T: 613-238-7200  
 F: 613-235-2005  
 E: mail@hobinarc.com  
 hobinarc.com  
**HOBIN ARCHITECTURE**

6			
5			
3	ISSUED FOR CONSTRUCTION	20171003	DV
2	ISSUED FOR PERMIT	20170705	DV
1	ISSUED FOR INFORMATION	20170623	DV
NUMBER	MILESTONE / FAT SAILLANT	DATE: (MM/DD)	INITIALS
DESIGNED BY / CONCEPTEUR	CHECKED BY / VÉRIFIEUR		
DRAWN BY / DESINER	SCALE / ÉCHELLE		
DV	1:50		

DETAIL NUMBER	DRAWING TITLE
A1.1	
SHEET NUMBER	

THIS DRAWING IS THE PROPERTY OF THE CITY OF OTTAWA AND ALL COPYRIGHT IS RESERVED. DIMENSIONS ON DRAWING ARE FOR ESTIMATING PURPOSES ONLY. IT IS THE RESPONSIBILITY OF EACH CONTRACTOR AND SUB-CONTRACTOR OR CONSULTANT TO CHECK AND VERIFY ALL DIMENSIONS AND CONDITIONS ON SITE. NOTIFY OWNER OF ANY ERRORS OR OMISSIONS PRIOR TO COMMENCING THE WORK. DO NOT SCALE THE DRAWINGS.

CE DESSIN CONSTITUE LA PROPRIÉTÉ DE LA VILLE D'OTTAWA ET TOUT DROIT D'AUTEUR EST RÉSERVÉ. LES DIMENSIONS UTILISÉES SE SONT À DES FINS D'ESTIMATION SEULEMENT. IL INCOMBE À CHAQUE ENTREPRENEUR, SOUS-CONTRACTANT OU CONSULTANT DE VÉRIFIER TOUTES LES DIMENSIONS ET LES CONDITIONS SUR LE CHANTIER. VEUILLEZ INFORMER LE PROPRIÉTAIRE DE TOUTE ERREUR OU OMISSION AVANT D'ENTAMER LES TRAVAUX. NE DRESSEZ PAS LES PLANS À L'ÉCHELLE.

ARCHITECT / ARCHITECTE	CONSULTANT / EXPERT-CONSEIL
CONSULTANT / EXPERT-CONSEIL	CONSULTANT / EXPERT-CONSEIL

PROJECT / LOCATION / PROJET / ENDROIT  
**DOVERCOURT**  
**PHASE 2**  
**ADDITION & RENOVATION**  
 411 DOVERCOURT  
 OTTAWA, ONTARIO  
 DRAWING / DESSIN  
**FLOOR PLANS**  
**DEMOLITION PLAN**

1 GROUND FLOOR DEMOLITION PLAN  
 D1.01 SCALE 1:50