


1 NEW GROUND FLOOR PLAN
M100 SCALE: 1:100

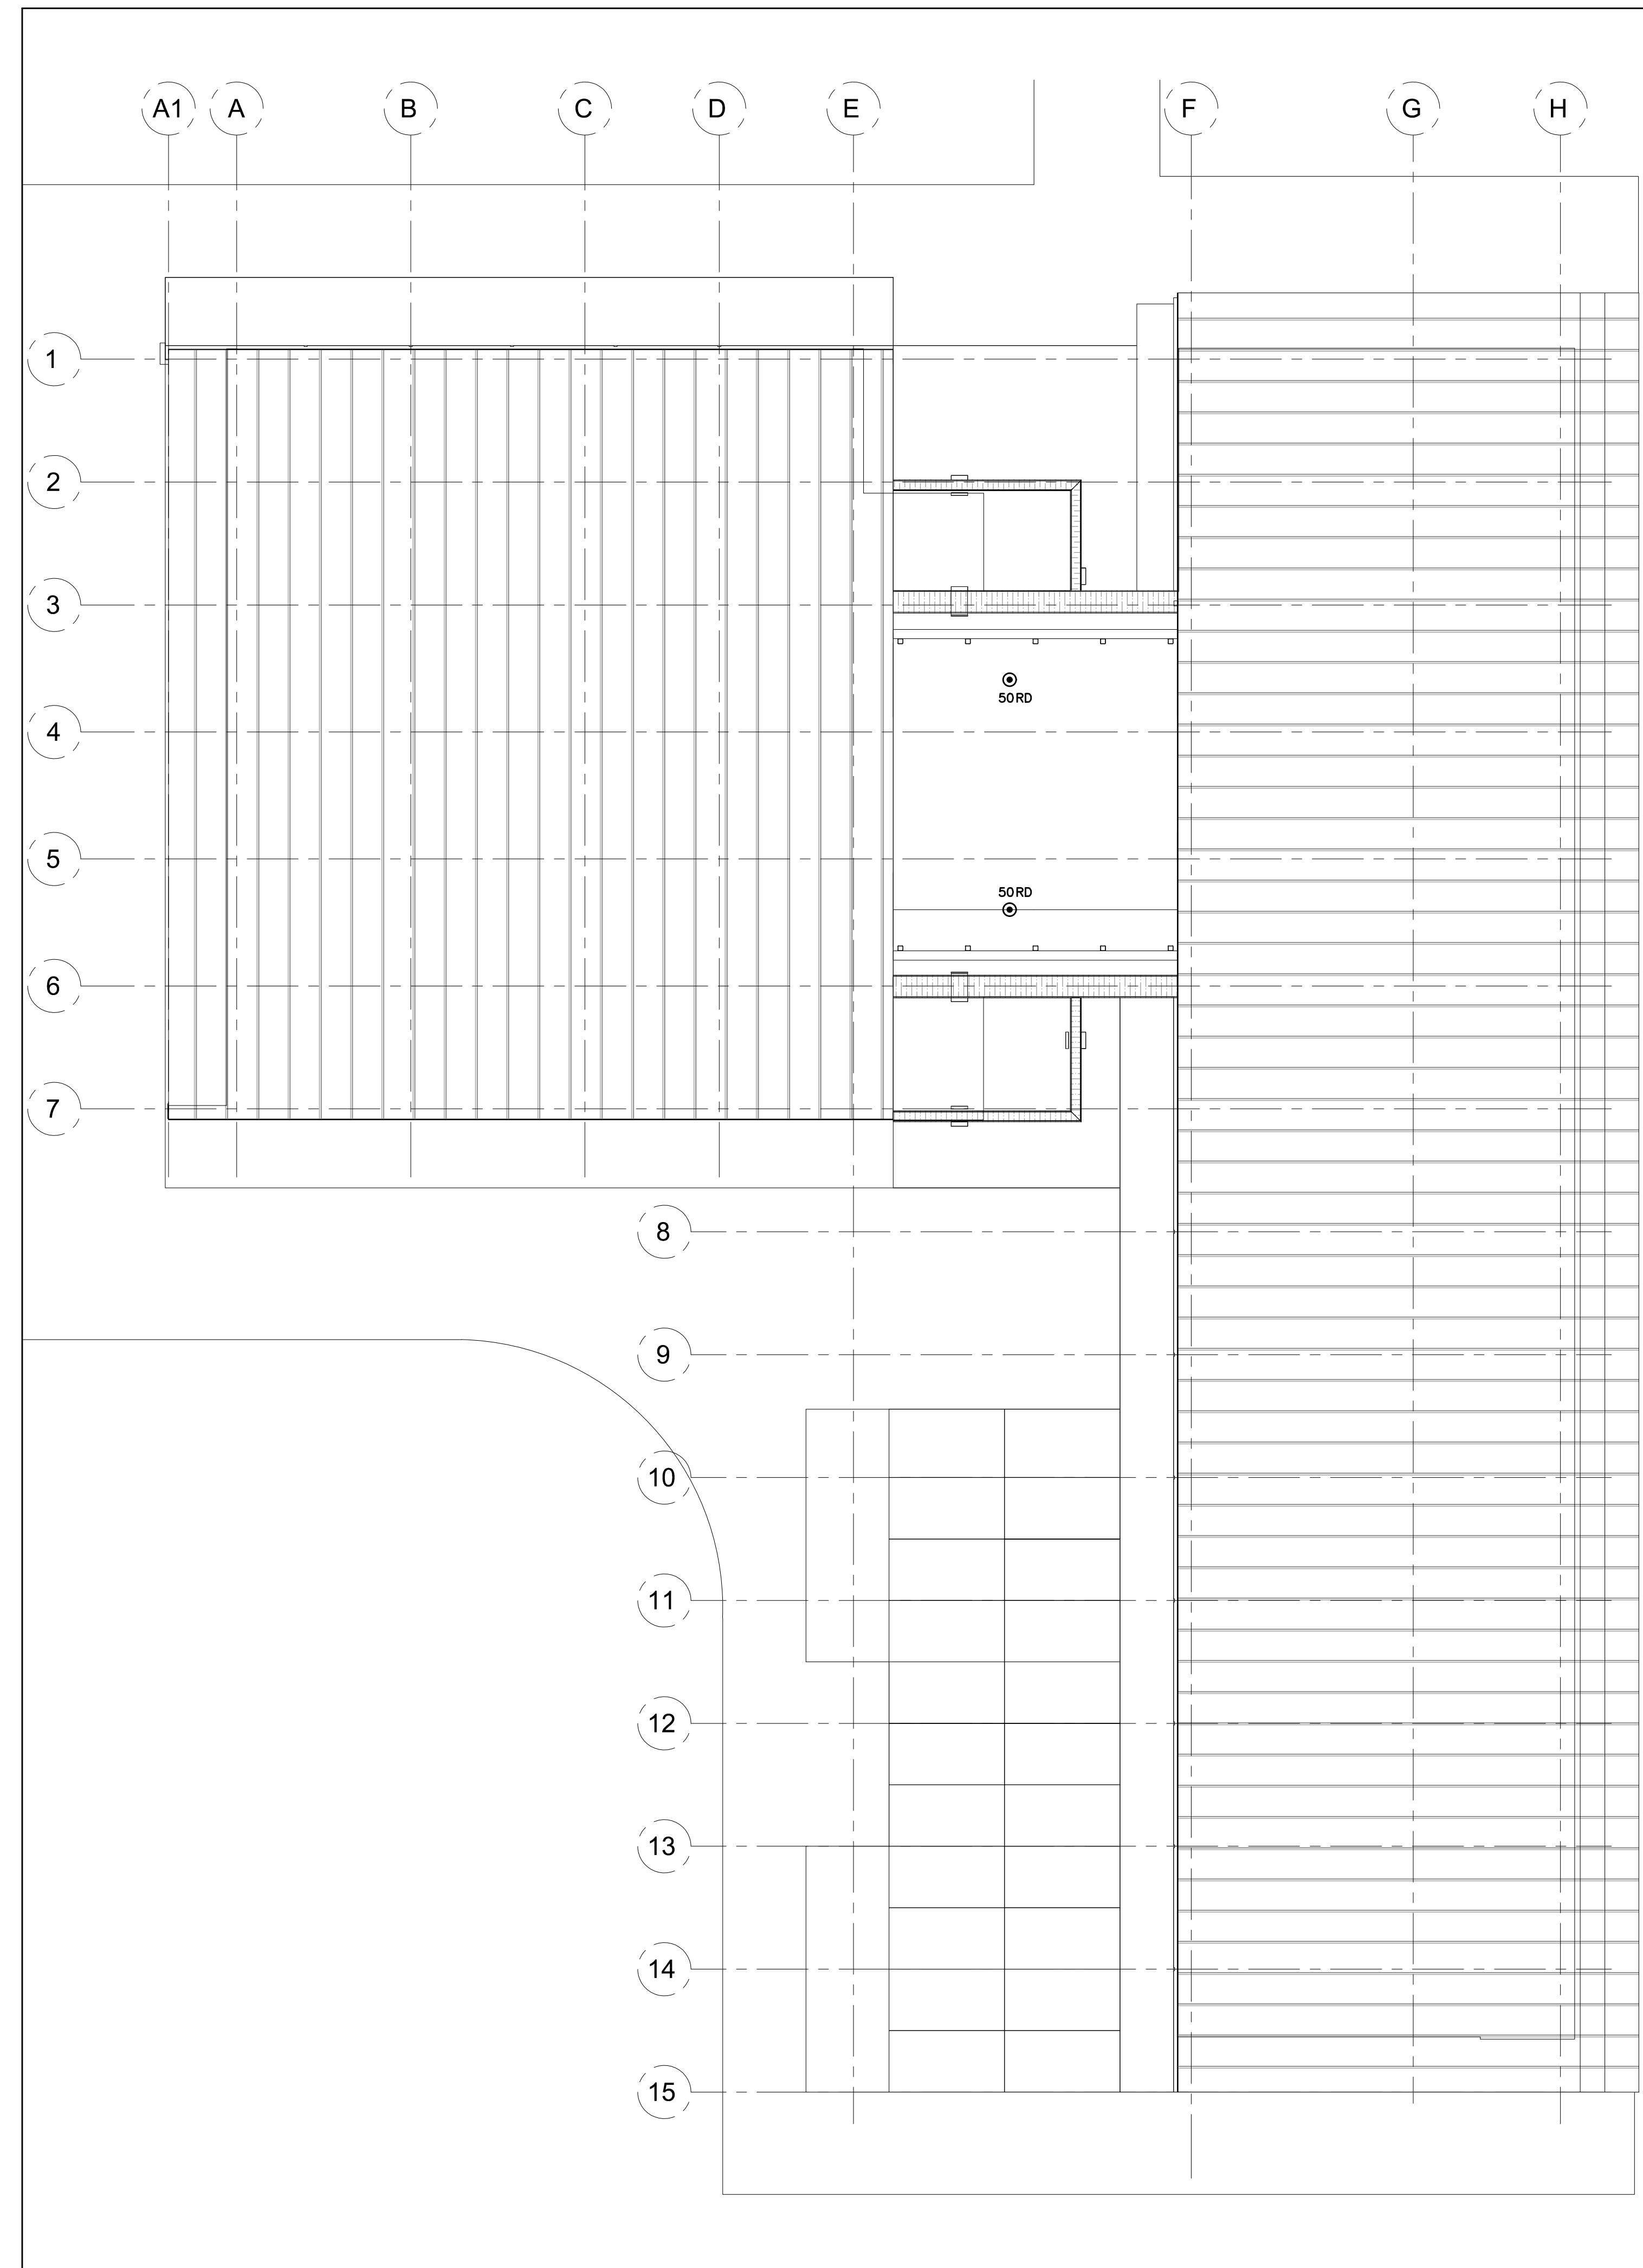

2 NEW ROOF PLAN
M100 SCALE: 1:100

IT IS THE RESPONSIBILITY OF THE APPROPRIATE CONTRACTOR TO CHECK AND VERIFY ALL DIMENSIONS ON SITE AND TO REPORT ALL ERRORS AND/OR OMISSIONS TO THE ARCHITECT.

ALL CONTRACTORS MUST COMPLY WITH ALL PERTINENT CODES AND BY-LAWS.

THIS DRAWING MAY NOT BE USED FOR CONSTRUCTION UNTIL SIGNED BY THE ARCHITECT.

DO NOT SCALE DRAWINGS

COPYRIGHT RESERVED



VR 16-178

NO.	ISSUED FOR	DATE
6	ISSUED FOR TENDER	12.10.2017
5	ISSUED FOR PRE-TENDER REVIEW	25.08.2017
4	ISSUED FOR 95% REVIEW	18.08.2017
3	ISSUED FOR 90% REVIEW	09.08.2017
2	ISSUED FOR REVIEW	07.07.2017
1	ISSUED FOR 33% REVIEW	23.12.2016
#	ISSUED FOR	DD/MM/YY

ARCHITECT SEAL:	NORTH ARROW:

CLIENT:

ARCHITECT:

PROJECT TITLE:
MCNAB BRAESIDE

ARNPRIOR ONTARIO

SHEET TITLE:

TOWN HALL - NEW PLUMBING AND FIRE PROTECTION PLAN

DRAWN: AW	CHECKED: IF
SCALE: 1:100	SHEET No: M100
PROJECT No: 16-178	