


- NEW NOTES**
- ① PROVIDE NEW DEVICES AND CONNECT AS INDICATED IN BOLD.
  - ② ALL CONDUIT AND WIRING SHALL BE CONCEALED. ROUTE THROUGH EXPOSED STRUCTURE, ALONG BEAMS AND PERLINS WITHIN BULKHEADS OR DROP CEILING. EMT SHALL BE USED IN EXPOSED CEILING AREAS. REFER TO ARCHITECTURAL CEILING PLANS AND DETAILS.
  - ③ PROVIDE EMERGENCY CALL FOR B-F WASHROOM.

ROUTE CONDUIT/CABLE UNDER WINDOW (AROUND COLUMNS)

**1 FLOOR PLAN**  
E202 SCALE: 1:100

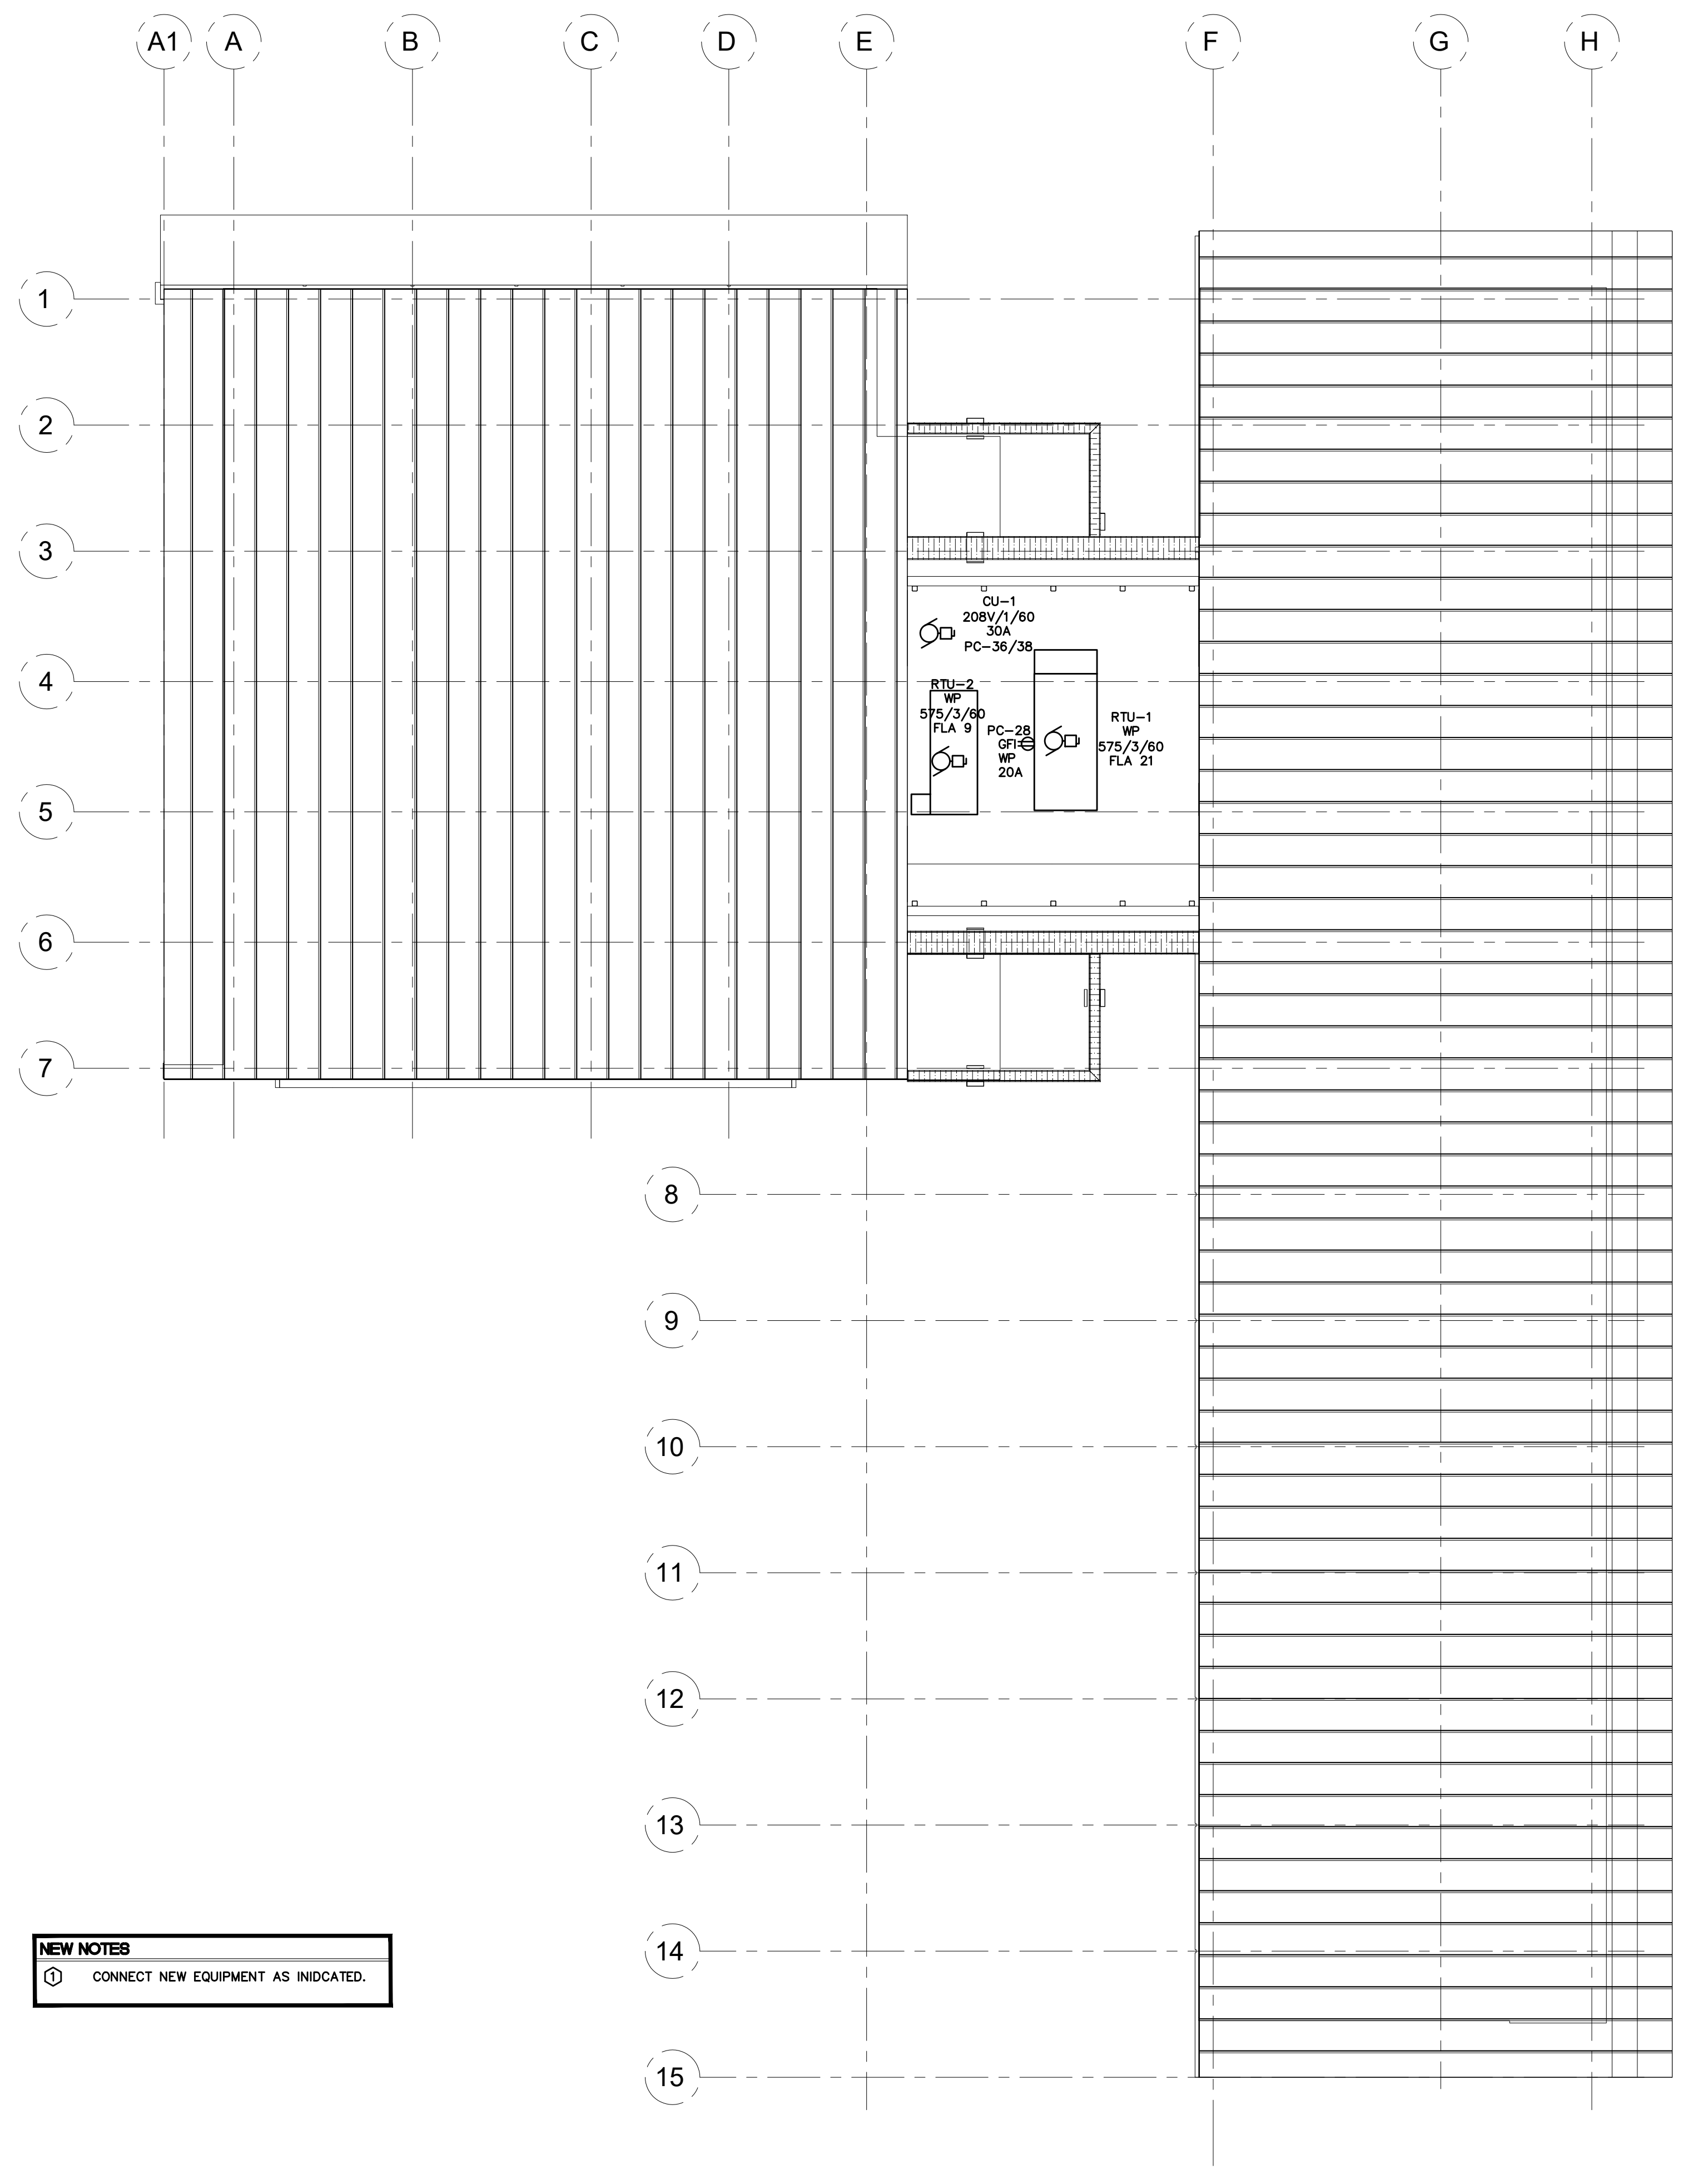

- NEW NOTES**
- ① CONNECT NEW EQUIPMENT AS INDICATED.

**2 ROOF PLAN**  
E202 SCALE: 1:100

IT IS THE RESPONSIBILITY OF THE APPROPRIATE CONTRACTOR TO CHECK AND VERIFY ALL DIMENSIONS ON SITE AND TO REPORT ALL ERRORS AND/OR OMISSIONS TO THE ARCHITECT.  
ALL CONTRACTORS MUST COMPLY WITH ALL PERTINENT CODES AND BY-LAWS.  
THIS DRAWING MAY NOT BE USED FOR CONSTRUCTION UNTIL SIGNED BY THE ARCHITECT.  
DO NOT SCALE DRAWINGS  
COPYRIGHT RESERVED



VR 16-178

6	ISSUED FOR TENDER	12.10.2017
5	ISSUED FOR PRE-TENDER REVIEW	25.08.2017
4	ISSUED FOR 95% REVIEW	18.08.2017
3	ISSUED FOR 90% REVIEW	09.08.2017
2	ISSUED FOR REVIEW	07.07.2017
1	ISSUED FOR 33% REVIEW	23.12.2016
#	ISSUED FOR	DDMMYY

REVISIONS:

ARCHITECT SEAL: \_\_\_\_\_ NORTH ARROW:

CLIENT: \_\_\_\_\_

ARCHITECT: \_\_\_\_\_

PROJECT TITLE:  
**MCNAB BRAESIDE**

ARNPRIOR ONTARIO

SHEET TITLE:  
**TOWN HALL - FLOOR & ROOF - NEW POWER & SYSTEMS PLAN**

DRAWN: JOP	CHECKED: SB
SCALE: 1:100	SHEET No: <b>E202</b>
PROJECT No: 16-178	