



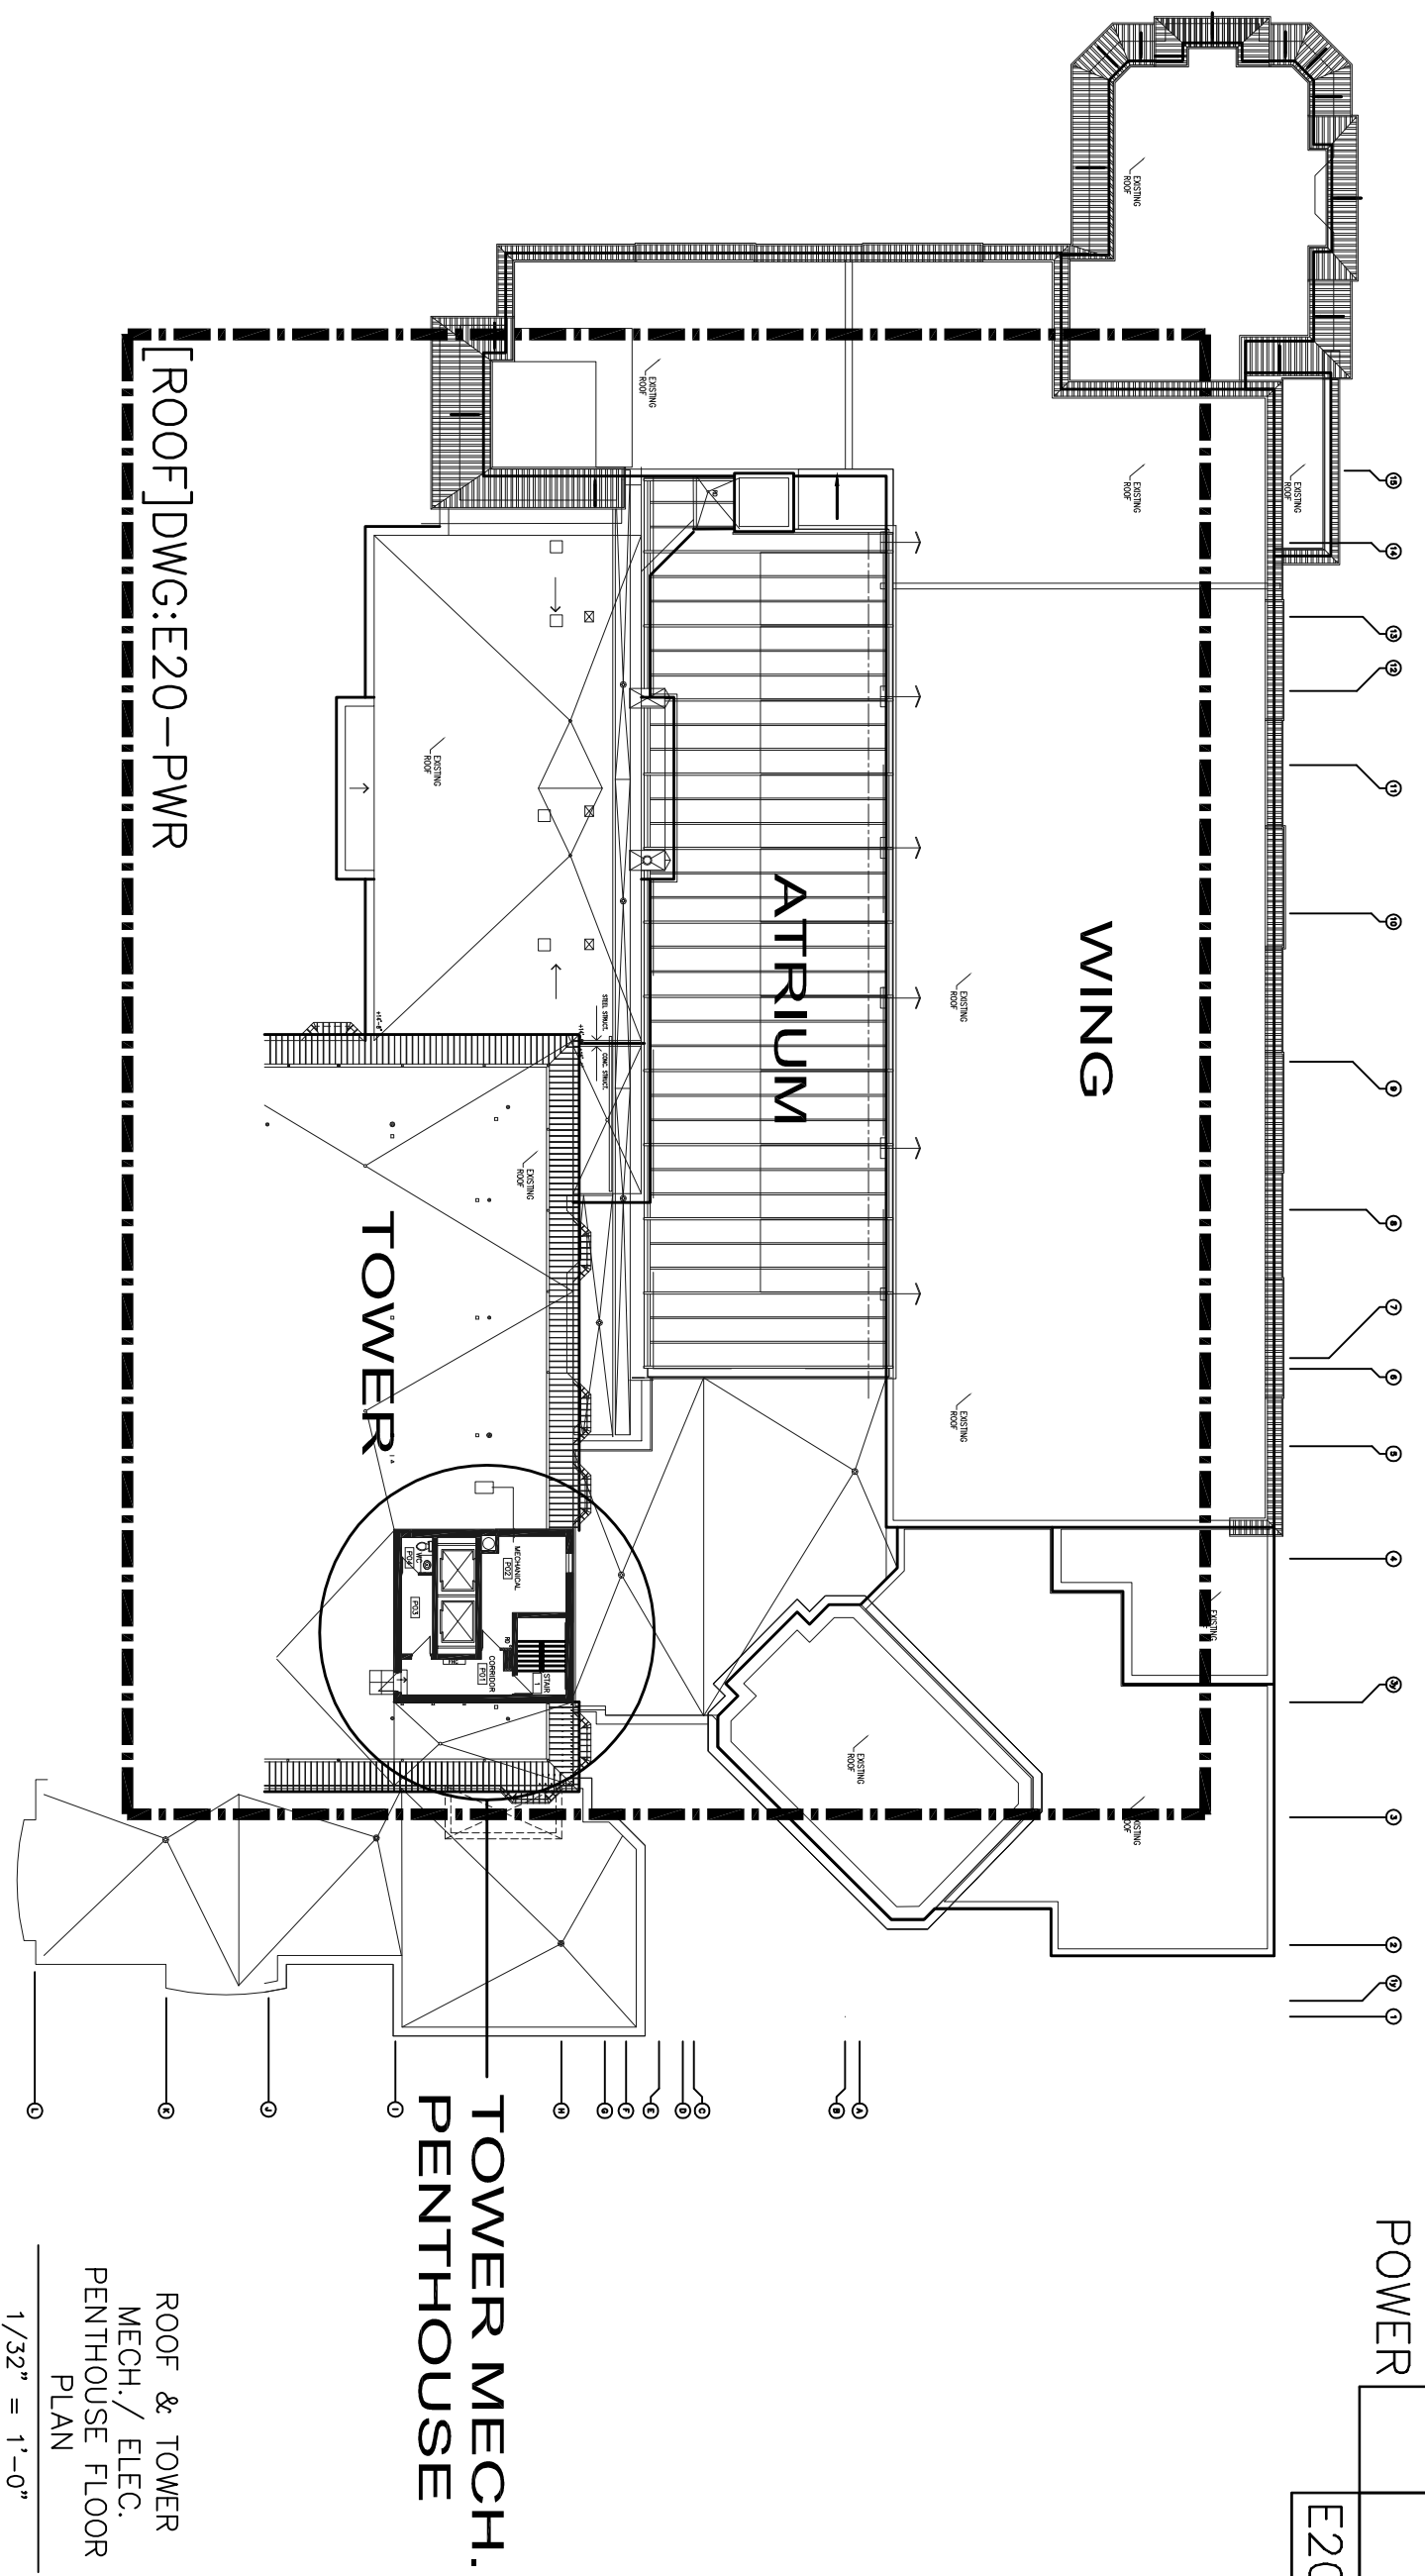

POWER [E20]

ROOF & TOWER
MECH./ ELEC.
PENTHOUSE FLOOR
PLAN


1/32" = 1'-0"

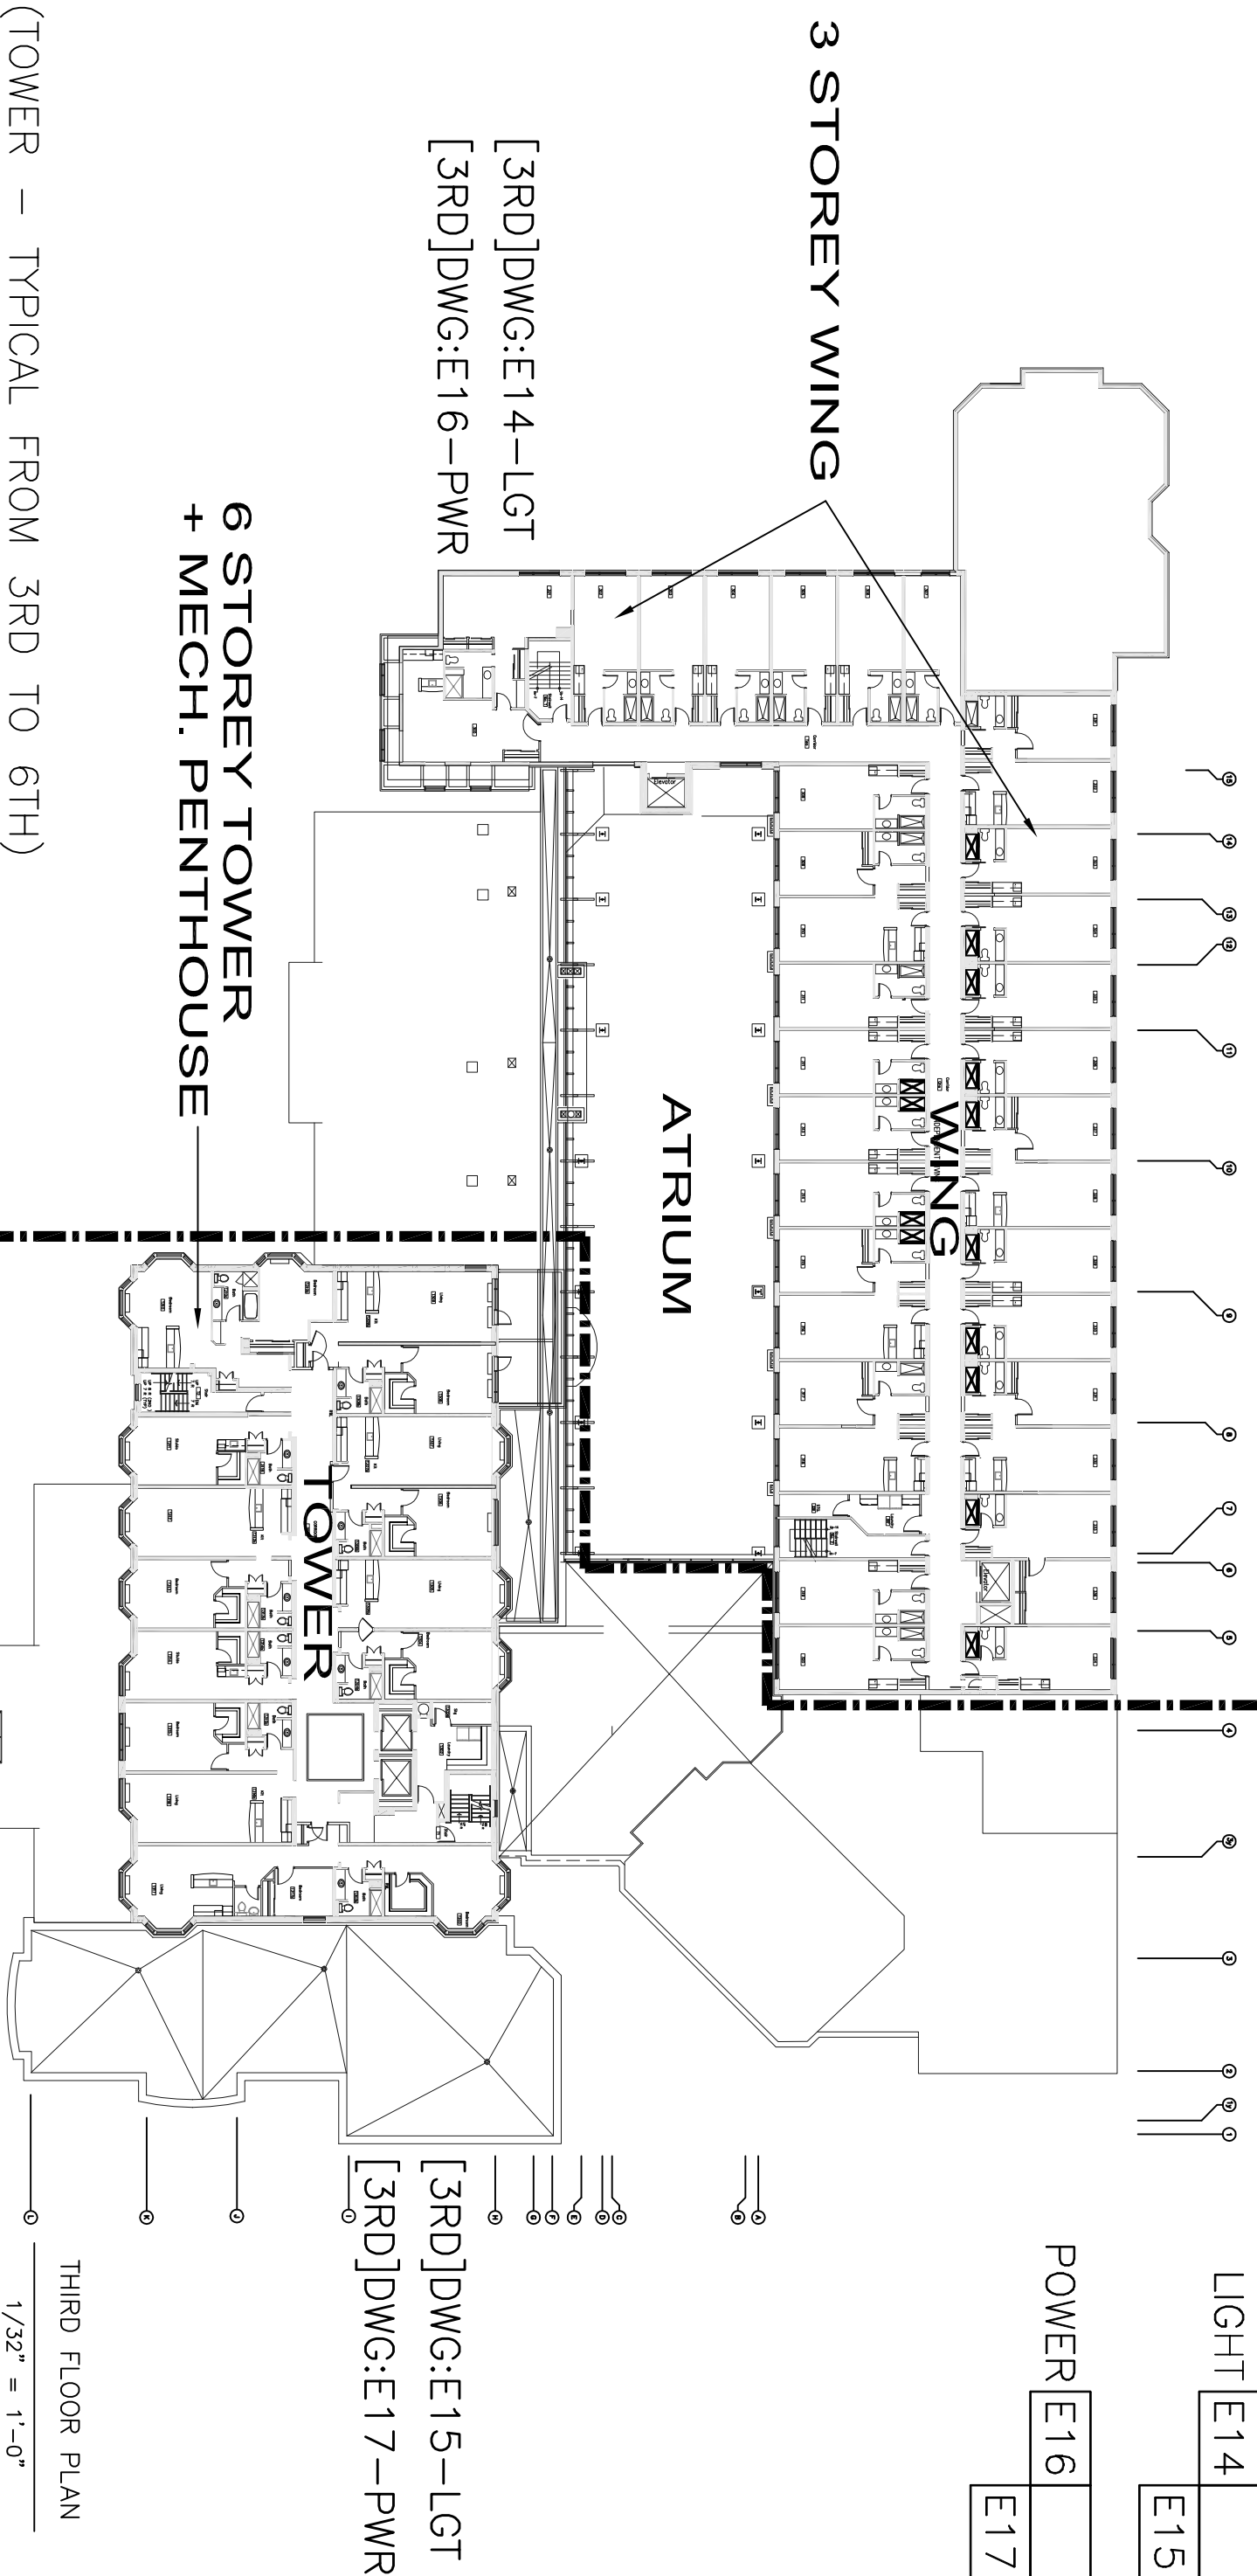

LIGHT [E14]
[E15]
POWER [E16]
[E17]

THIRD FLOOR PLAN


1/32" = 1'-0"

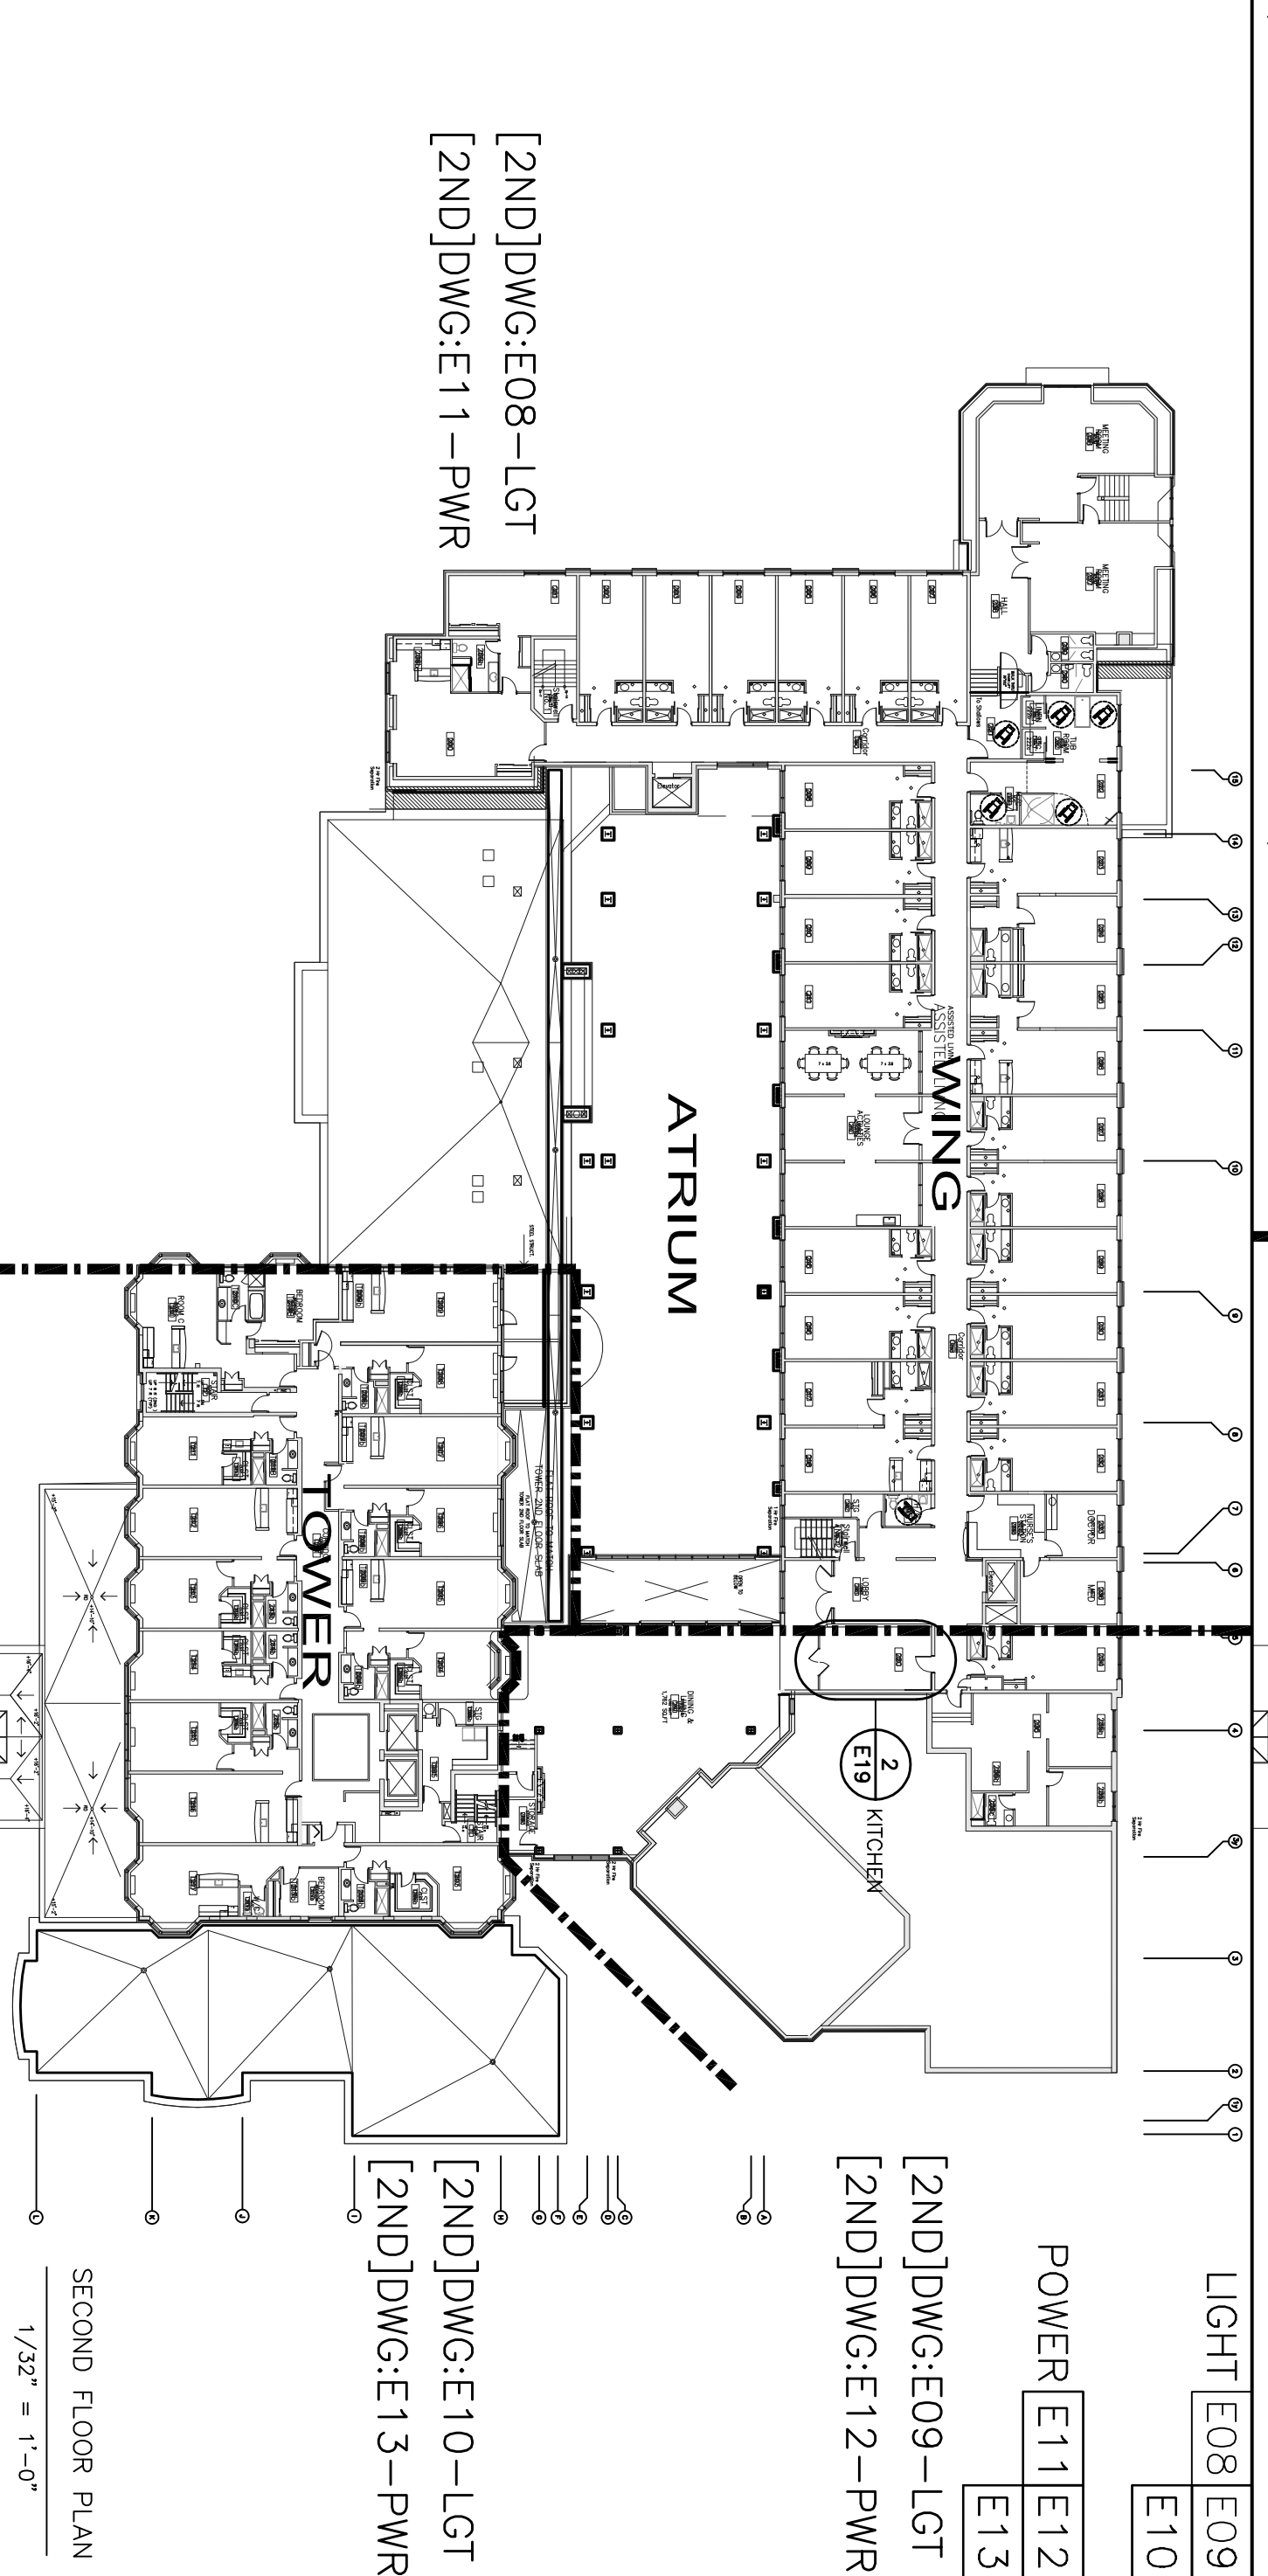

POWER [E11]
[E12]
[E13]
[2ND]DWG:E09-LGT
[2ND]DWG:E12-PWR
LIGHT [E08]
[E09]
[E10]

SECOND FLOOR PLAN

1/32" = 1'-0"

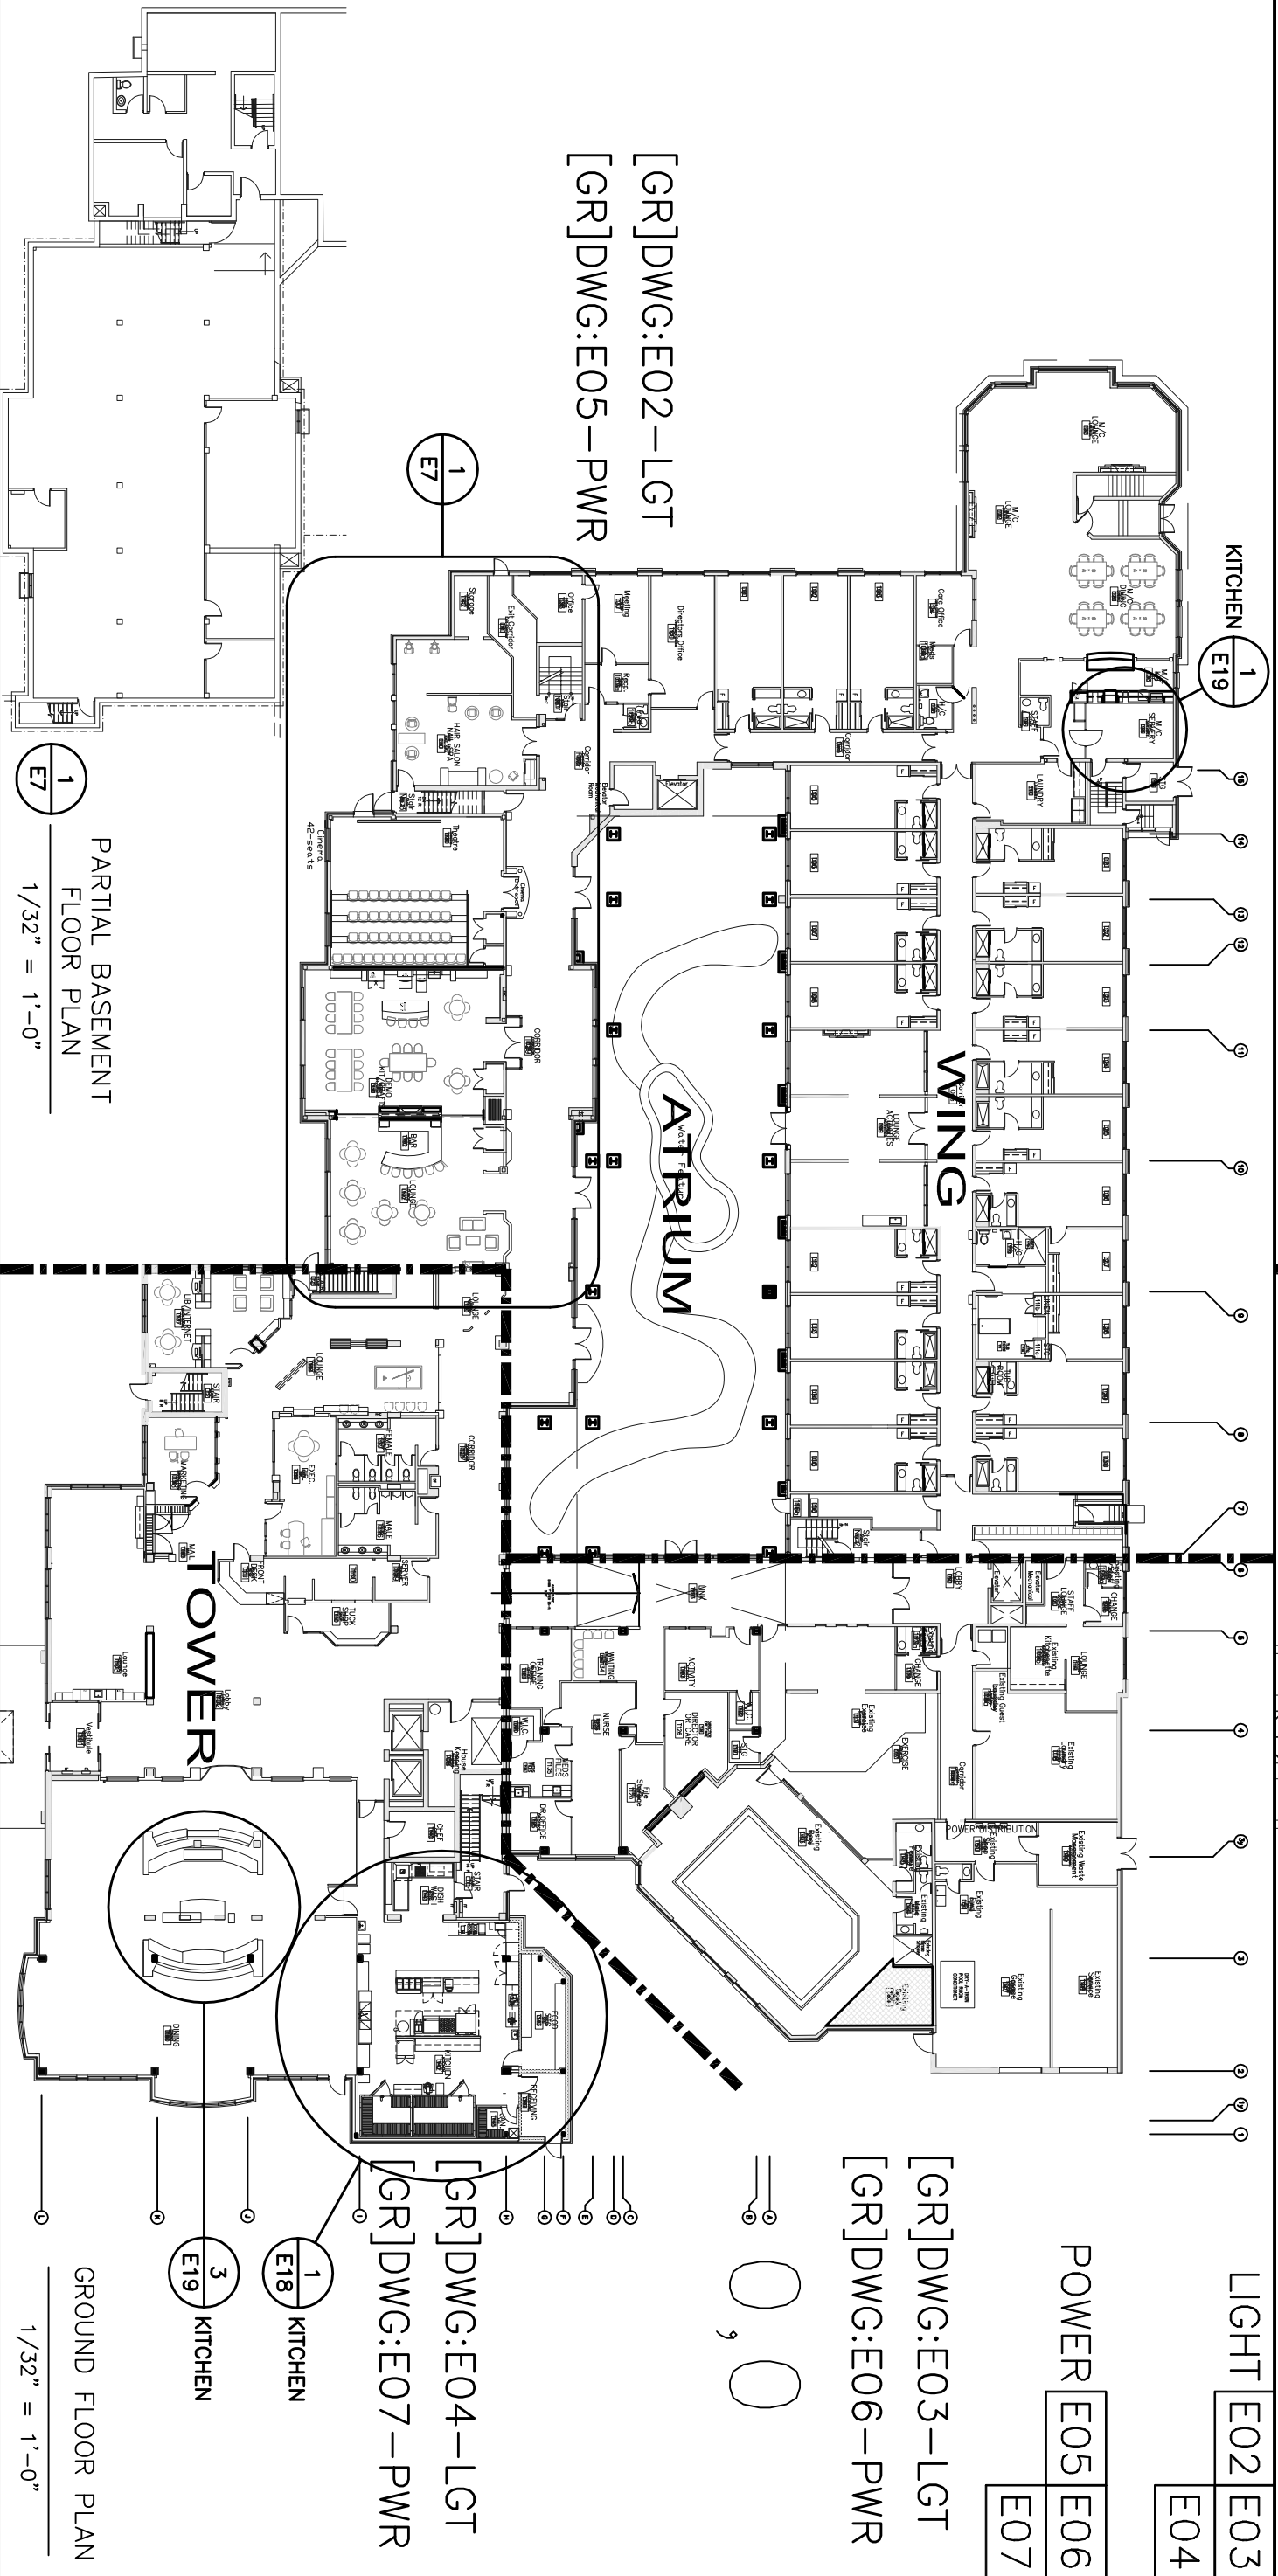

POWER [E05]
[E06]
[E07]
[GR]DWG:E03-LGT
[GR]DWG:E06-PWR
LIGHT [E02]
[E03]
[E04]

GROUND FLOOR PLAN

1/32" = 1'-0"

ALL LIGHT SWITCHES TO BE MOUNTED 1100mm AFT - TAKEN FROM TOP OF FINISH FLOOR LEVEL, 1447" TO CENTER OF OUTLET BOX.

ALL F/A RAIL STATIONS TO BE MOUNTED 1200mm AFT - TAKEN FROM TOP OF FINISH FLOOR LEVEL, 1447" TO CENTER OF OUTLET BOX.

EXACT LOCATION OF EQUIPMENT WITH MECHANICAL TO COORDINATION WITH ARCHITECT.

ALL PARTY CONDUIT TO BE C/W FULL ROPE.

GENERAL NOTES:

REVISION

NO.	DATE	REVISION
01	DEC 23/14	ISSUED FOR PERMIT
02	APR 16/15	RE-ISSUED FOR PERMIT
03	JUN 02/15	ISSUED FOR REVIEW
04	JUN 15/15	PROGRESS ISSUE
05	JUN 22/15	PROGRESS ISSUE
06	JULY 20/15	ISSUED FOR PROING

QUADRANT

ENGINEERING LIMITED, CONSULTING ENGINEERS
1700 BAYVIEW AVENUE, SUITE 200, SCARBOROUGH, ONTARIO, CANADA M1T 3H5
TEL: (416) 361-1467 FAX: (416) 361-1463
E-Mail: info@quadrantengineering.ca

S.J.L

S. J. LAWRENCE
ARCHITECT INCORPORATED
28 BAYVIEW AVE, SUITE 200, SCARBOROUGH, ONTARIO M2H 3B7
TEL: (416) 753-7777 FAX: (416) 753-7770
WWW.SJLARCHITECT.COM

REVISION

NO.	DATE	REVISION
01	MAR 14	AS
02	MAR 18, 2014	1/8"=1'-0"

REVISION

SOUTHWAY INN
RETRO-FIT
RETIREMENT HOME

REVISION

REFERENCE KEY
PLANS FROM
BASEMENT TO ROOF

REVISION

E29