



<b>TAL-CO SUPPLEMENTAL INSTRUCTION #73</b>			
<b>REVISED FLOOR 2 EXEC OFFICE LAYOUT - 225A &amp; 225B</b>			
Project Name:	<b>RW TOMLINSON - NEW HEAD OFFICE</b>		
Project Location:	<b>100 CitiGate Drive, Ottawa, Ontario</b>		
ARCH. SI #:	<b>ASK'S 210, 211 &amp; 212</b>	Issued By:	<b>Farah Bano</b>
STRUC. SI #:	<b>N/A</b>	Date Issued:	<b>December 1, 2017</b>
MECH. SI #:	<b>N/A</b>	Revision #:	<b>N/A</b>
ELEC. SI #:	<b>N/A</b>	Revision Date:	<b>N/A</b>

Supplemental Instructions are issued by the Construction Manager to record a clarification or revision to the previously issued Contract Documentation as reflected by the attached information prepared by the identified Professionals.

The Construction Manager shall review the Supplemental Instruction and the attached information and issue to the affected Trade Contractors identifying the following course of action by the Trade Contractor.

Notify TAL-CO within 5 days of receipt, if the attached documents will require a change to Contract Price or Schedule.

**TITLE: REVISED FLOOR 2 EXEC OFFICE LAYOUT - 225A & 225B**

**Reference:**

Architectural Construction Update 28-Jul-2017

**Attachments:**

- ASK 210
- ASK 211
- ASK 212

**Description of the work:**

Previous Office 225 layout revised to create two separate offices 225A & 225B. Please review for any changes required on your end. Changes include but are not limited to drywall/ glass partition / ductwork / fire safety / flooring / signage requirements.

Architectural sketches are for implementation. Electrical and Mechanical details to follow.

**Reason:**


Requested by owner.



D223	915	2750	SGD-1	N/A	SGS-14	N/A	N/A
D224	915	2750	SGD-1	N/A	SGS-15	N/A	N/A
D225A	915	2750	SGD-1	N/A	SGS-16	N/A	N/A
D225B	915	2750	SGD-1	N/A	SGS-14	N/A	N/A
D226	915	2750	SGD-1	N/A	SGS-14	N/A	N/A
D227	915	2750	SGD-1	N/A	SGS-17	N/A	N/A



THE ANNEX/480 EGLINTON ST. OTTAWA, ON K1R6G5  
 613.567.7888 PHONE / 613.567.7528 FAX  
 csaarchitect.com

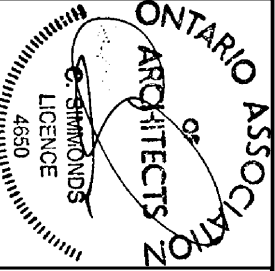

PROJECT:  
**TOMLINSON NEW BUILDING**

DRAWING TITLE:  
**REFERENCE PARTIAL DETAIL 6/A901**

DATE: 11/30/2017


SCALE: 1:50

DRAWN BY: JK


JOB No: 574-15

DRAWING No:

**ASK-211**

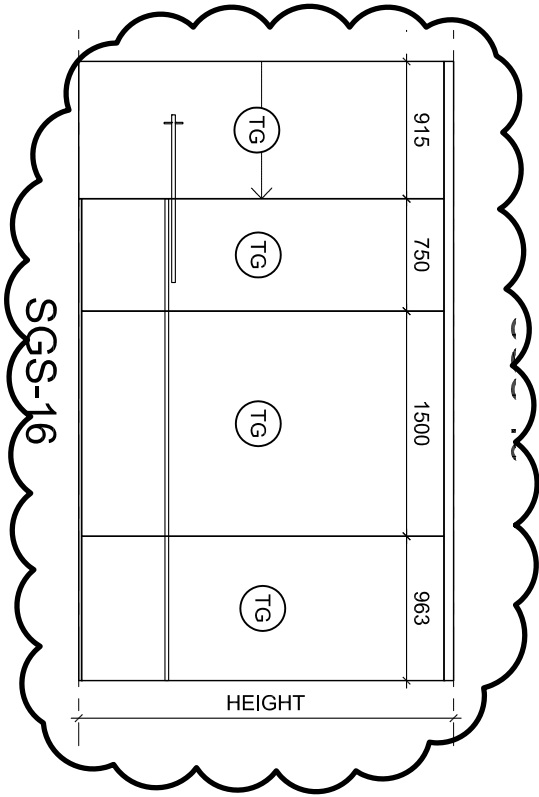

THE ANNEX/486 CECLES ST. OTTAWA, ON K1R6G5  
 613.567.7888 PHONE / 613.567.7528 FAX  
 csaarchitect.com

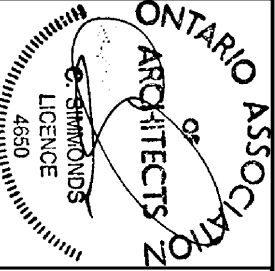

PROJECT:  
**TOMLINSON NEW BUILDING**

DRAWING TITLE:  
**REFERENCE PARTIAL DETAIL 8/A901**

DATE: 11/30/2017

SCALE: 1:50

DRAWN BY: JK

JOB No: 574-15

DRAWING No:

**ASK-212**