


LEGEND

- TC = 4' x 2' TEACHER'S CABINET, SEE SPECIFICATION DOCUMENTS
- TE = 18" x 18" TELE-COMMUNICATION CENTRE, SEE SPECIFICATION DOCUMENTS
- WF = WALL MOUNTED WATER FOUNTAIN, SEE MECHANICAL DOCUMENTS
- TB-1 = 48" x 9" TACK BOARD (TYP. IN ALL CLASSROOMS) SEE SPECIFICATION DOCUMENTS
- WB-1 = 86" x 72" WHITEBOARD (TYP. IN ALL CLASSROOMS) SEE SPECIFICATION DOCUMENTS

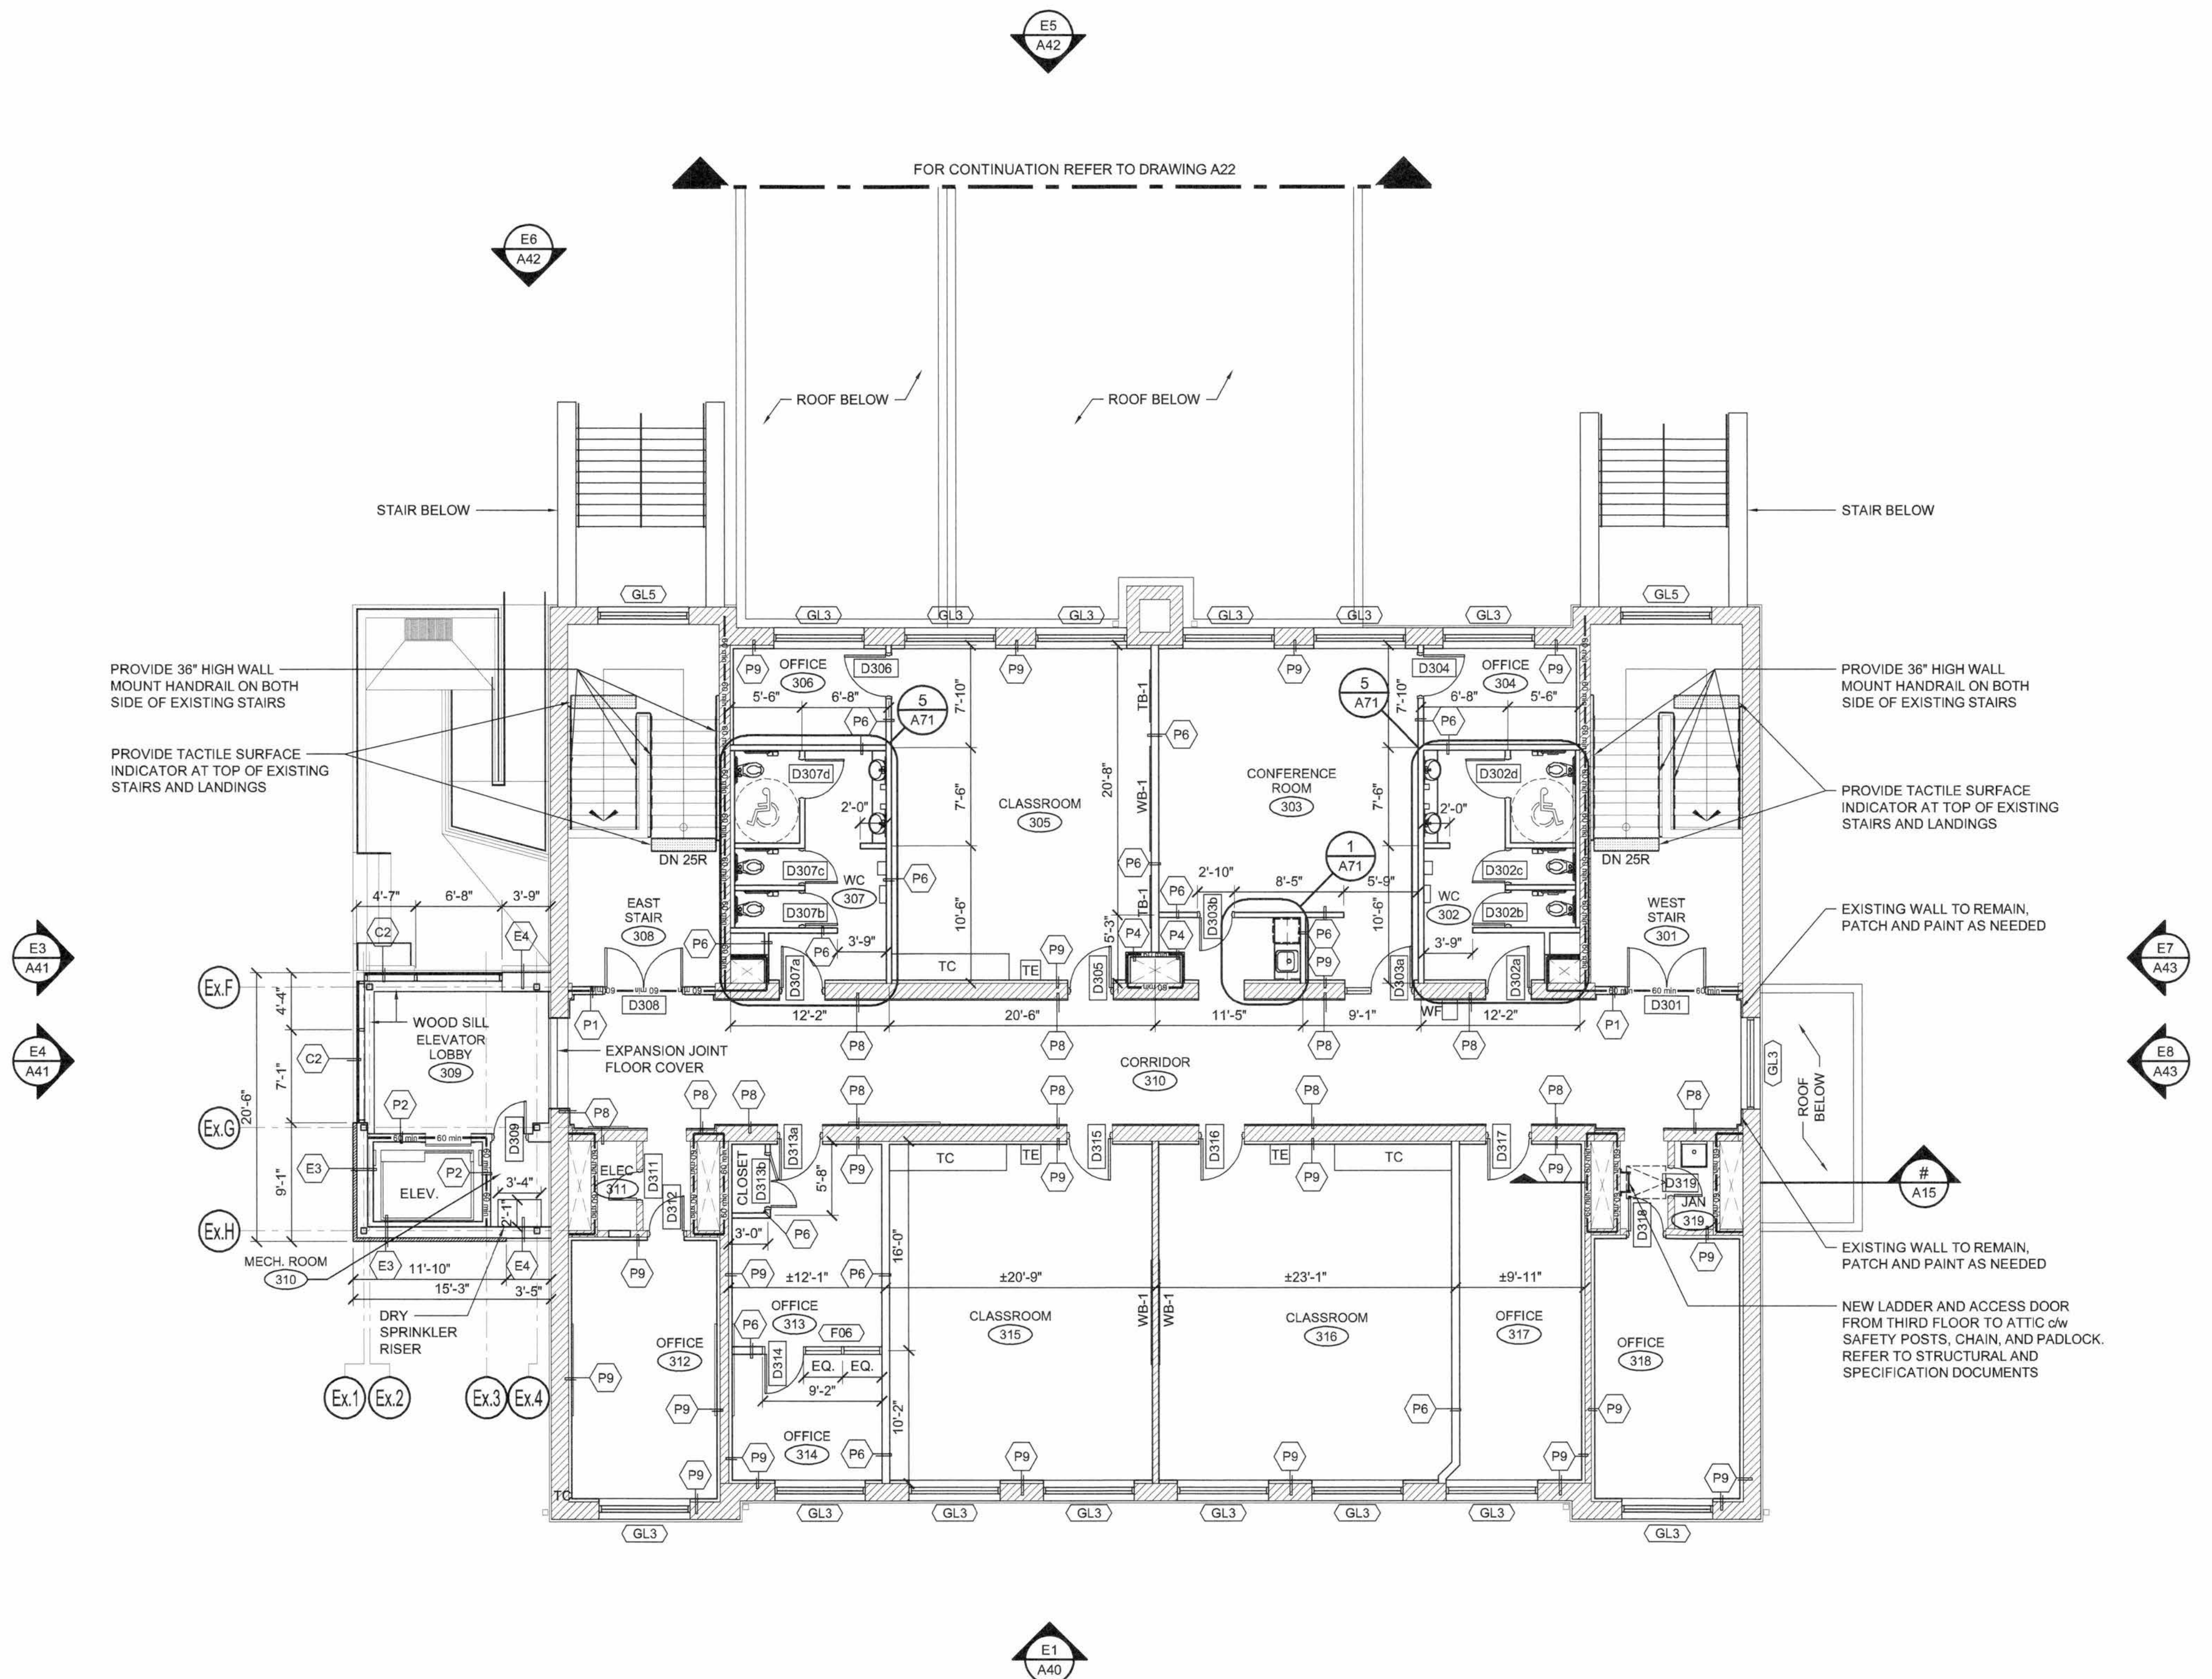

1 THIRD FLOOR PLAN
SCALE: 1/8" = 1'-0"

1	FOR TENDER	01/06/18
No.	ISSUE / REVISION	DDMMYY

This drawing is copyright protected and may not be reproduced or used for purposes other than execution of the described work without the express written consent of J.L. Richards & Associates Limited.

VERIFY SHEET SIZE AND SCALES. BAR TO THE RIGHT IS 1" IF THIS IS A FULL SIZE DRAWING.


SCALE: 0 1'


CLIENT:
 Conseil des écoles publiques de l'Est de l'Ontario

CONSULTANT:
 McINTOSH PERRY Consulting Engineers Ltd.

CONSULTANT:
 J.L. Richards ENGINEERS - ARCHITECTS - PLANNERS

CONSULTANT:
 PAGEAU MOREL
www.pageaumorel.com
Gatineau

PROFESSIONAL STAMP
 ONTARIO ASSOCIATION OF ARCHITECTS
SÉBASTIEN RACINE
LICENCE 5441

PROJECT NORTH


PROJECT:
MAISON DE LA FRANCOPHONIE D'OTTAWA
2720 RICHMOND ROAD, OTTAWA

DRAWING:
THIRD FLOOR PLAN

DESIGN: SD	DRAWING #:
DRAWN: MM	A13
CHECKED: SD	
JLR #:	

27672-001