

**GENERAL NOTES**

1. DO NOT SCALE DRAWINGS. FIGURED DIMENSIONS ONLY TO BE USED.
2. IT IS THE RESPONSIBILITY OF THE CONTRACTOR TO CHECK AND VERIFY ALL DIMENSIONS ON SITE AND REPORT ANY DISCREPANCIES TO THE ARCHITECT.
3. ALL WORK DESCRIBED UNDER THIS CONTRACT TO COMPLY WITH THE MOST CURRENT EDITION OF THE ONTARIO BUILDING CODE, AND/OR NATIONAL BUILDING CODE, AND OTHER CODES AND BY-LAWS IN EFFECT.



**Antares Engineering Group Inc.**  
Professional Engineering, Electrical, Training and  
Construction Services  
159 Cambridge Road, Unit 1, Ottawa, Ontario, K2J 7J4  
Phone: (613) 232-5093 Fax: (613) 232-5799

**ISSUE RECORD**

No	DATE	REVISION
4	8-11-2019	ISSUED FOR TENDER
3	27-06-2019	ISSUED FOR BUILDING PERMIT
2	28-09-2018	ISSUED FOR REVIEW
1	13-05-2016	ISSUED FOR CLIENT REVIEW

ACTUAL PROJECT MONTH MONTH

CLIENT:  
ENTERPRISE RENT-A-CAR  
RYAN FIRLOTTE  
T: 613-274-6934  
F: 1-800-495-2412

CONSULTANTS:  
HOLZMAN CONSULTANTS INC.  
(LAND DEVELOPMENT CONSULTANTS)  
1076 CASTLE HILL CRES  
OTTAWA, ONTARIO  
K2C 2A8  
T: 613-226-1386

MMM GROUP LTD  
(CIVIL ENGINEERING)  
1145 HUNT CLUB ROAD, SUITE 300  
OTTAWA, ONTARIO  
K1V 0Y3  
T: 613-738-7200  
F: 613-368-8710  
VALLEY ENGINEERING  
(STRUCTURAL ENGINEERING)  
521 DICKINSON AVENUE  
OTTAWA, ONTARIO  
K1V 7J4  
T: 613-521-9002  
ANTARES ENGINEERING  
(M&E ENGINEERING)  
1-159 COLONNADE ROAD  
NEPEAN, ONTARIO  
K2E 7L4  
T: 613-723-6034

DRAWING TITLE:	PROJECT TITLE:
ELECTRICAL LIGHTING DISTRIBUTION	225 HUNTING DRIVE HUNTING/PALLADIUM DR. ENTERPRISE
DRAWING TITLE:	
ELECTRICAL LIGHTING DISTRIBUTION	
DRAWN BY:	JOB NO.:
S.J.S.	15-610
CHECKED BY:	DRAWING NO.:
J.C.L.	E-3
SCALE:	
AS NOTED	



**ELECTRICAL**

**ELECTRICAL DRAWING NOTES:**

1. PROVIDE T-BAR CEILING MOUNTED LIGHT FIXTURES TYPE "A" & "B" TYPE 347V, 1%, C/W CONTACTOR AND WALL MOUNTED SWITCH. FOR DETAILS REFER TO LIGHTING SCHEDULE DRAWING BESIDE.
2. PROVIDE SURFACE MOUNTED LIGHT FIXTURES TYPE "C" TYPE 347V, 1%, C/W CONTACTOR AND WALL MOUNTED SWITCH. FOR DETAILS REFER TO LIGHTING SCHEDULE DRAWING WITH GENERAL TRADERS PRIOR TO FINAL INSTALLATION (TYPICAL AS SHOWN).
3. PROVIDE LIGHTING CONTROL WALL SWITCH C/W CONTACTOR 347V, 1% (TYPICAL AS SHOWN).
4. PROVIDE WALL AND CEILING MOUNTED EXIT SIGNS 120DC. FOR DETAILS AND SPECIFICATIONS REFER TO FIXTURE SCHEDULE BESIDE (TYPICAL FOR ALL).
5. PROVIDE NEW WALL MOUNTED POWER DISTRIBUTION PANELS "DP-1" 600V, 3%, 60Hz, 100A, 24 CIRCUITS, AND "DP-2" 208V, 3%, 60Hz, 125A, 42 CIRCUITS.
6. PROVIDE WALL MOUNTED BATTERY OPERATED EMERGENCY LIGHT FIXTURES C/W REMOVE FOR TESTING AND SPECIFICATIONS REFER TO FIXTURE SCHEDULE BESIDE (TYPICAL FOR ALL).

**LIGHTING FIXTURE SCHEDULE**


LABEL	MANUFACTURER	CATALOGUE MODEL NUMBER	DESCRIPTION	VOLTAGE	NO	BALLAST	WATTS	TYPE	REMARKS
"A"	ACQUITY	WHSPR 2X4 4000LM 35K 80 CRI MINI 347	T-BAR CEILING FIXTURE	347 V	-	LED	33.8	3500K	2x4 TYPE - OFFICE
"B"	ACQUITY	CLX L48 3000LM SET FOL 347 CLX L48 3000LM SET FOL 120	CORPUS BOARD CEILING FIXTURE	347 V 120 V	-	LED	20.32	3500K	1x4 TYPE - OFFICE
"C"	AMULITE	WPE4 LA3 8/AOK 347	SUSPENDED FIXTURE	347 V	-	LED	40-60	3500K	1x4 TYPE - VAPOR-PROOF
IR-HEAD	AMULITE	RAMB-1-12-20WQ-WHT	WALL FIXTURE	12 VDC	1	-	20	-	SURFACE MOUNTED
2R-HEAD	AMULITE	RAMB-2-12-20WQ-WHT	WALL FIXTURE	12 VDC	2	-	20	-	SURFACE MOUNTED
E-BATT.	AMULITE	EBS1-12-200-2M8-20WQ-WHT-AID	EMERGENCY BATTERY WALL FIXTURE	12 VDC	2	-	20	-	SURFACE MOUNTED
EXIT	AMULITE	EXS1-U-M-WHT-BAT	WALL FIXTURE	12 VDC	1	-	1	-	LED UNI. MOUNTING

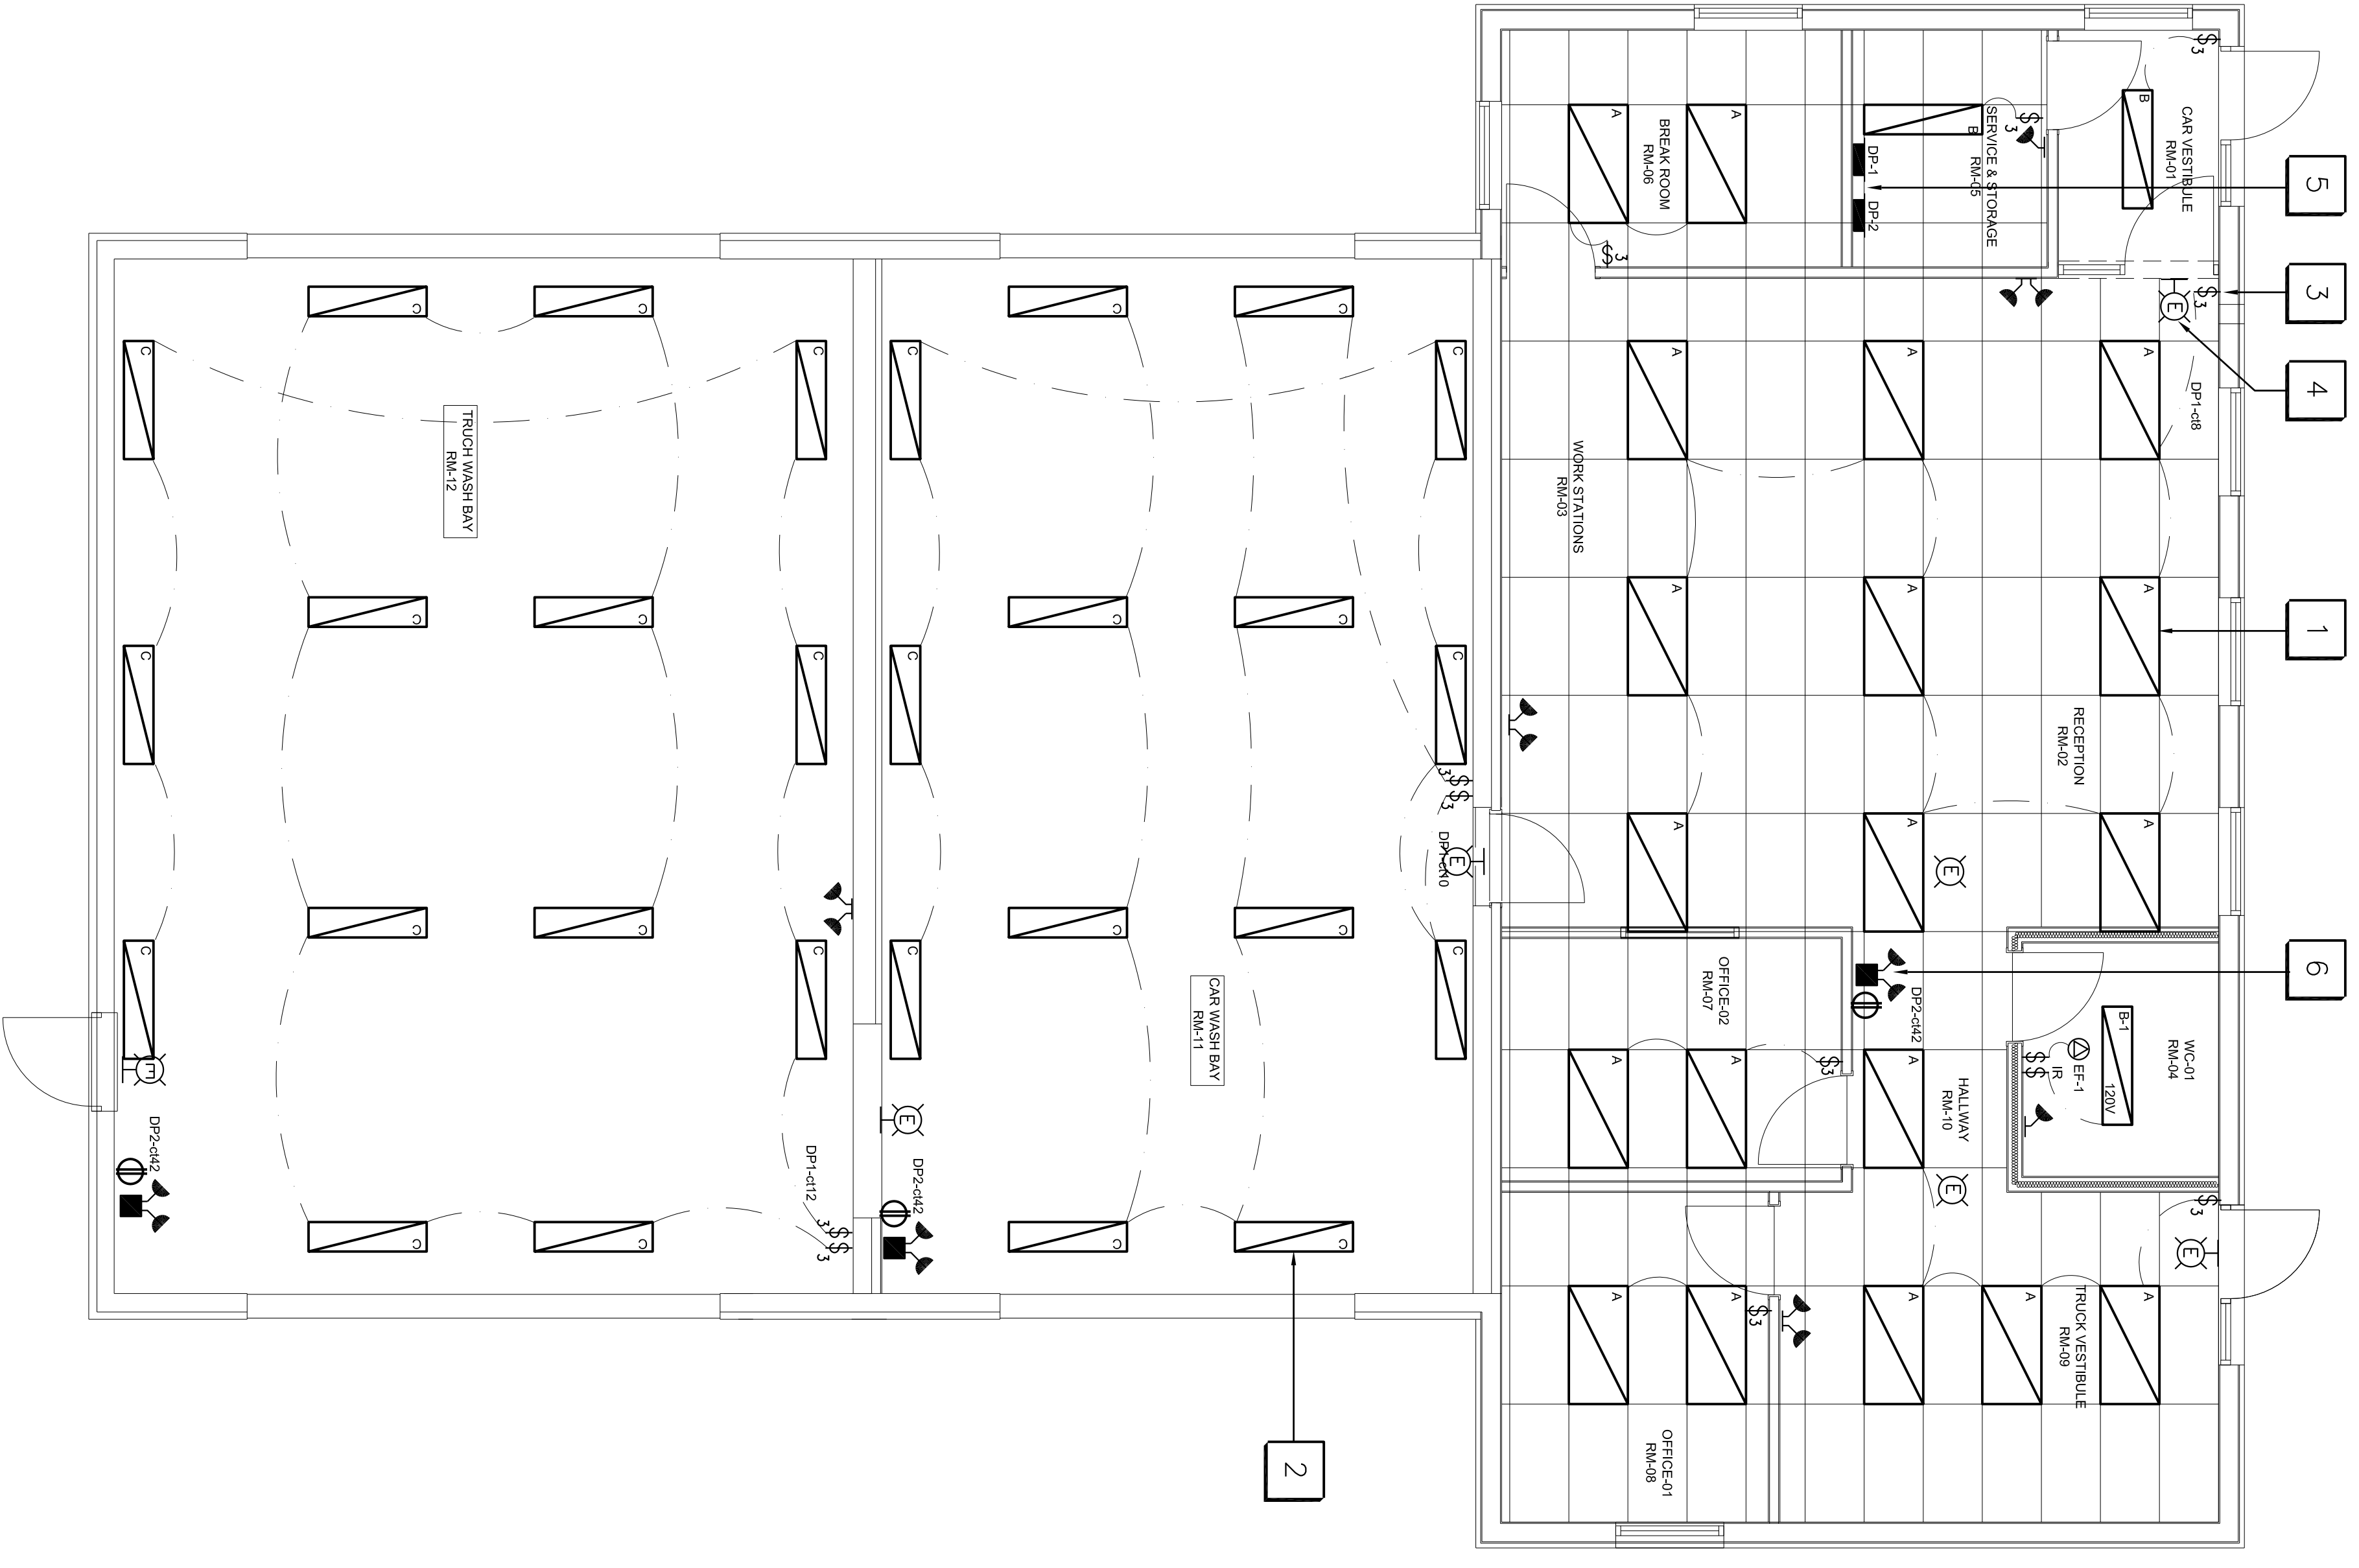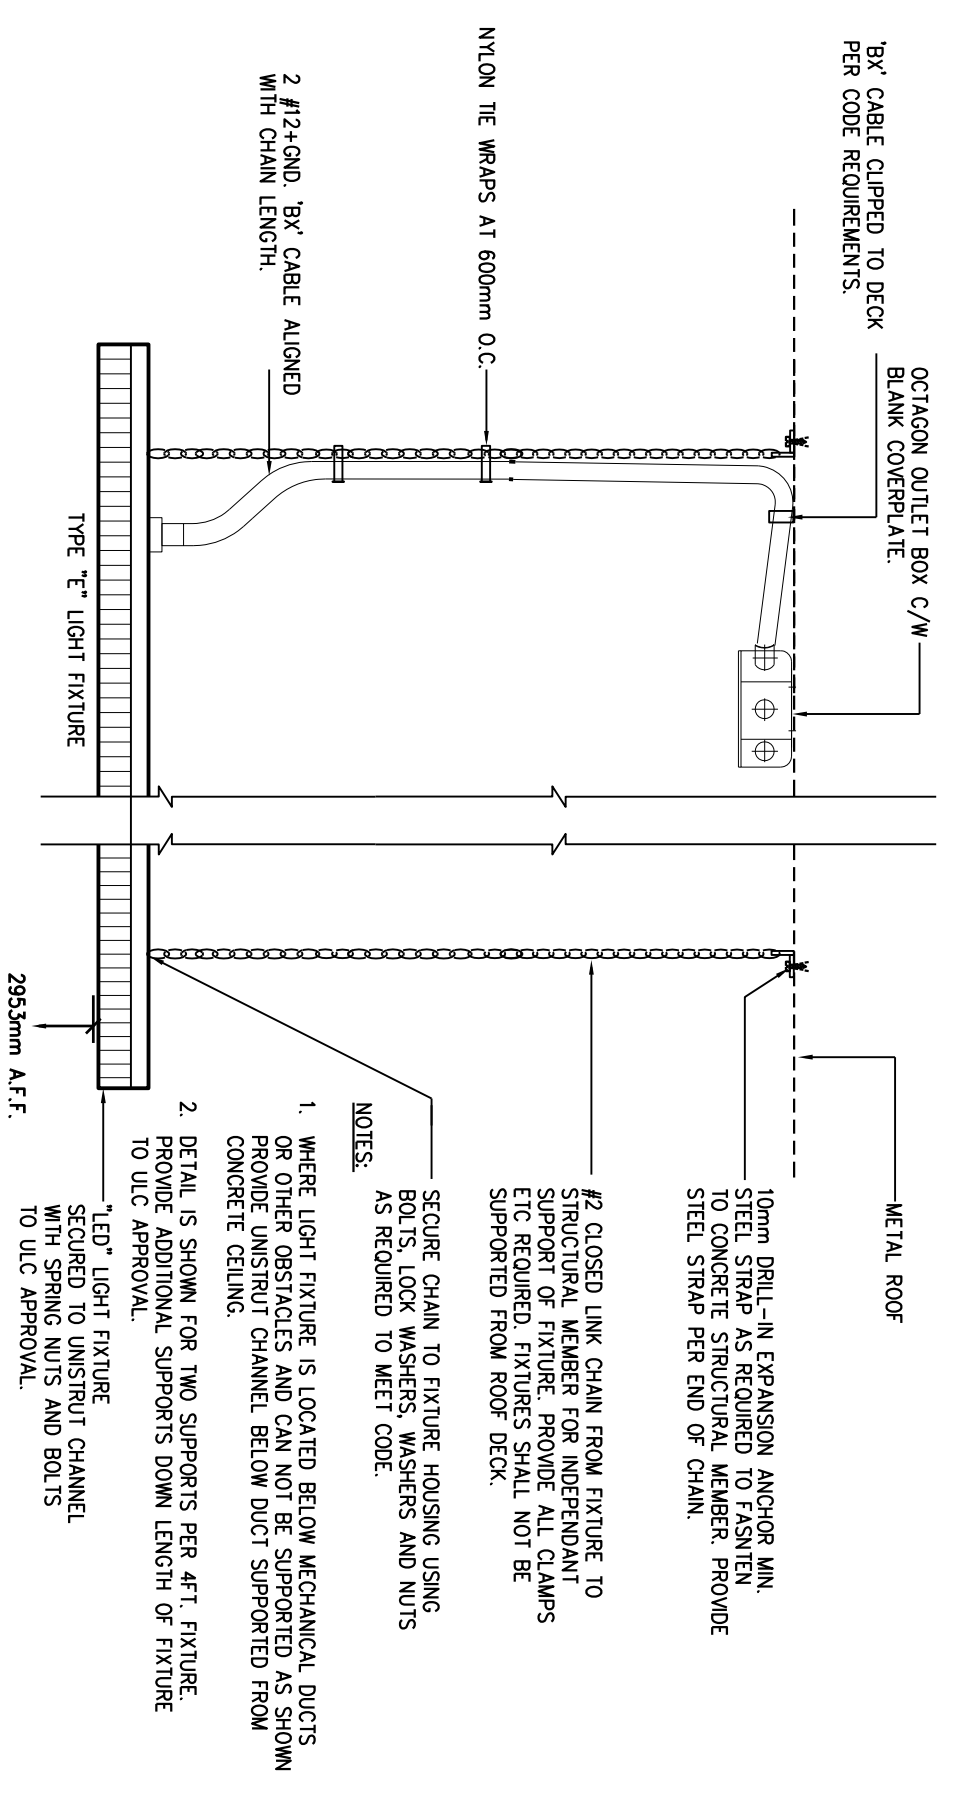

**1 ELECTRICAL CEILING PLAN**  
SCALE: 1 : 50

E-3

**2 T-BAR LIGHTING INSTALLATION DETAIL**  
SCALE: N.T.S.

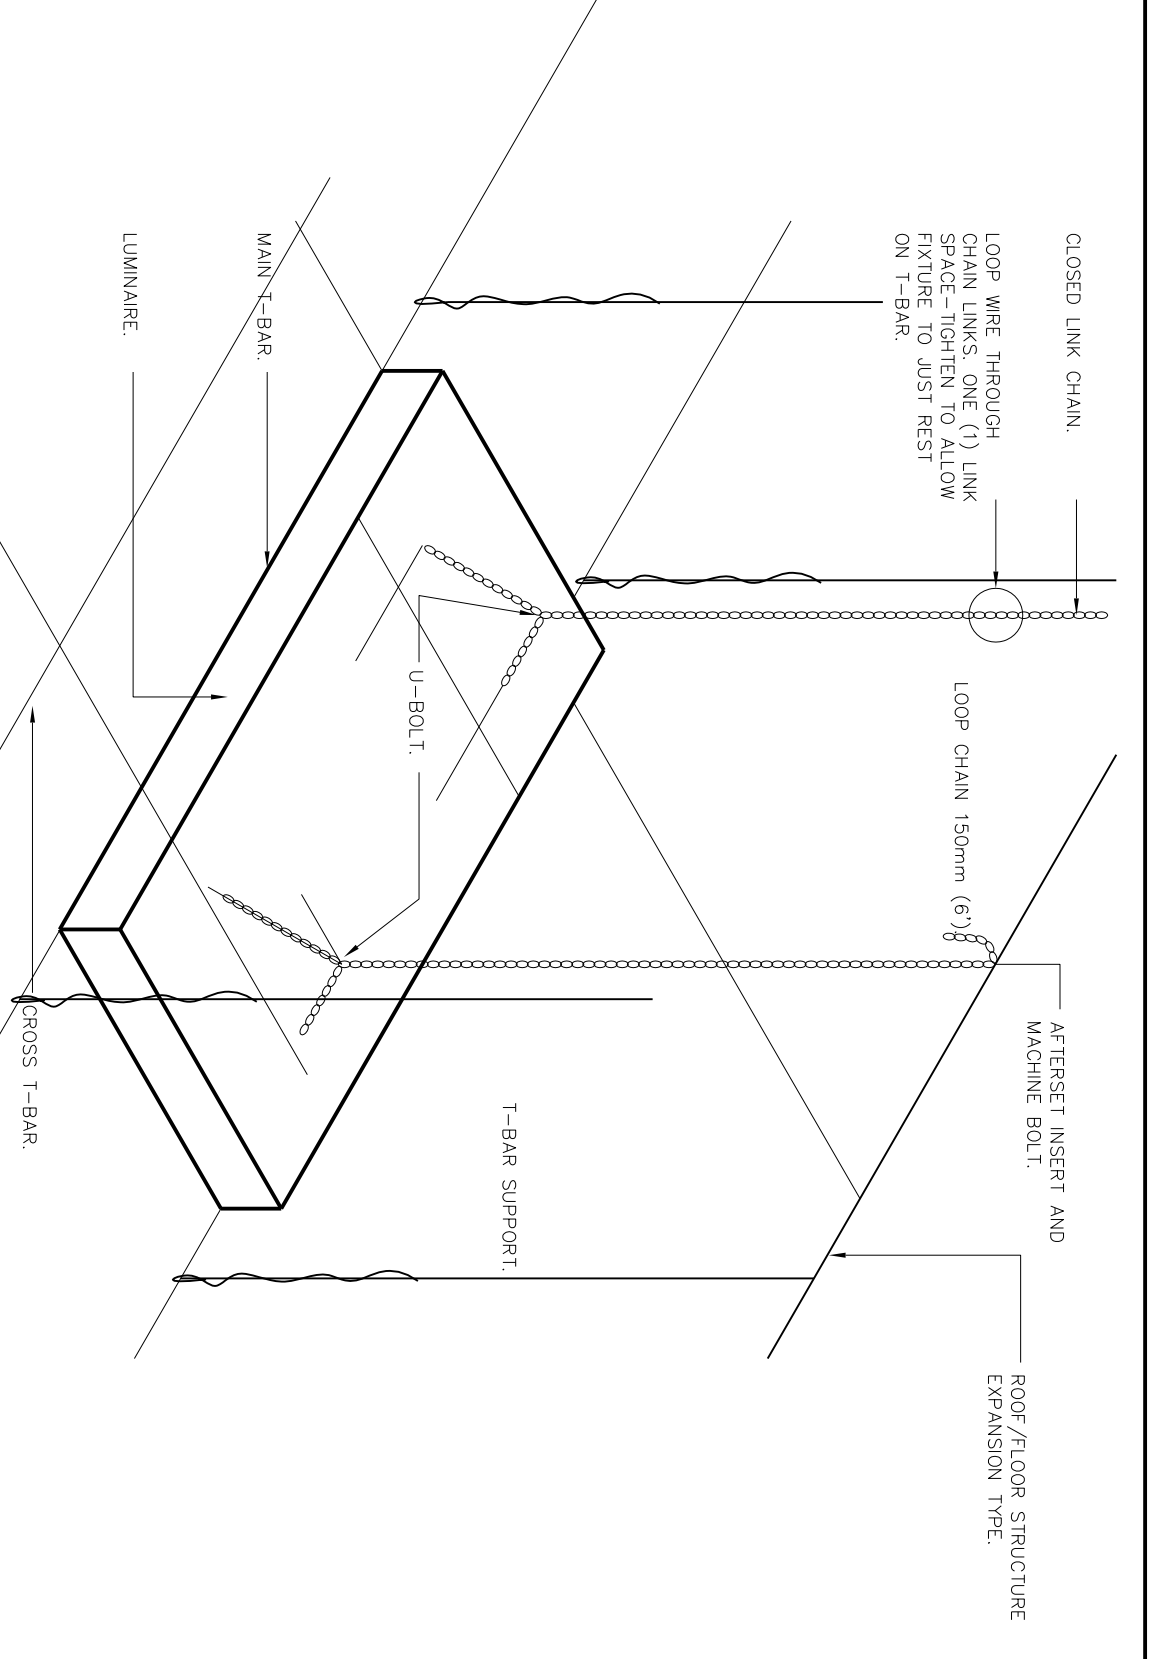

E2