

No.	Date	Revision
0	2020-09-22	FOR REVIEW

- LEGEND:**
- ⊗ HEAT DETECTOR
 - ⊙ SMOKE DETECTOR
 - ⊕ DUCT SMOKE DETECTOR
 - ▣ PULL STATION
 - ▾ FIRE ALARM HORN/STROBE


Client:
LARRY GAINES
ARCHITECT
Almonte, ON

Project:
CARLETON PLACE
ARENA ADDITION
Carleton Place, ON


Drawing:
Fire Alarm System

Design:	M.MORRIS
Drawn:	A.M.
Date:	SEP 2020
Project:	205
Scale:	AS SHOWN

FA1

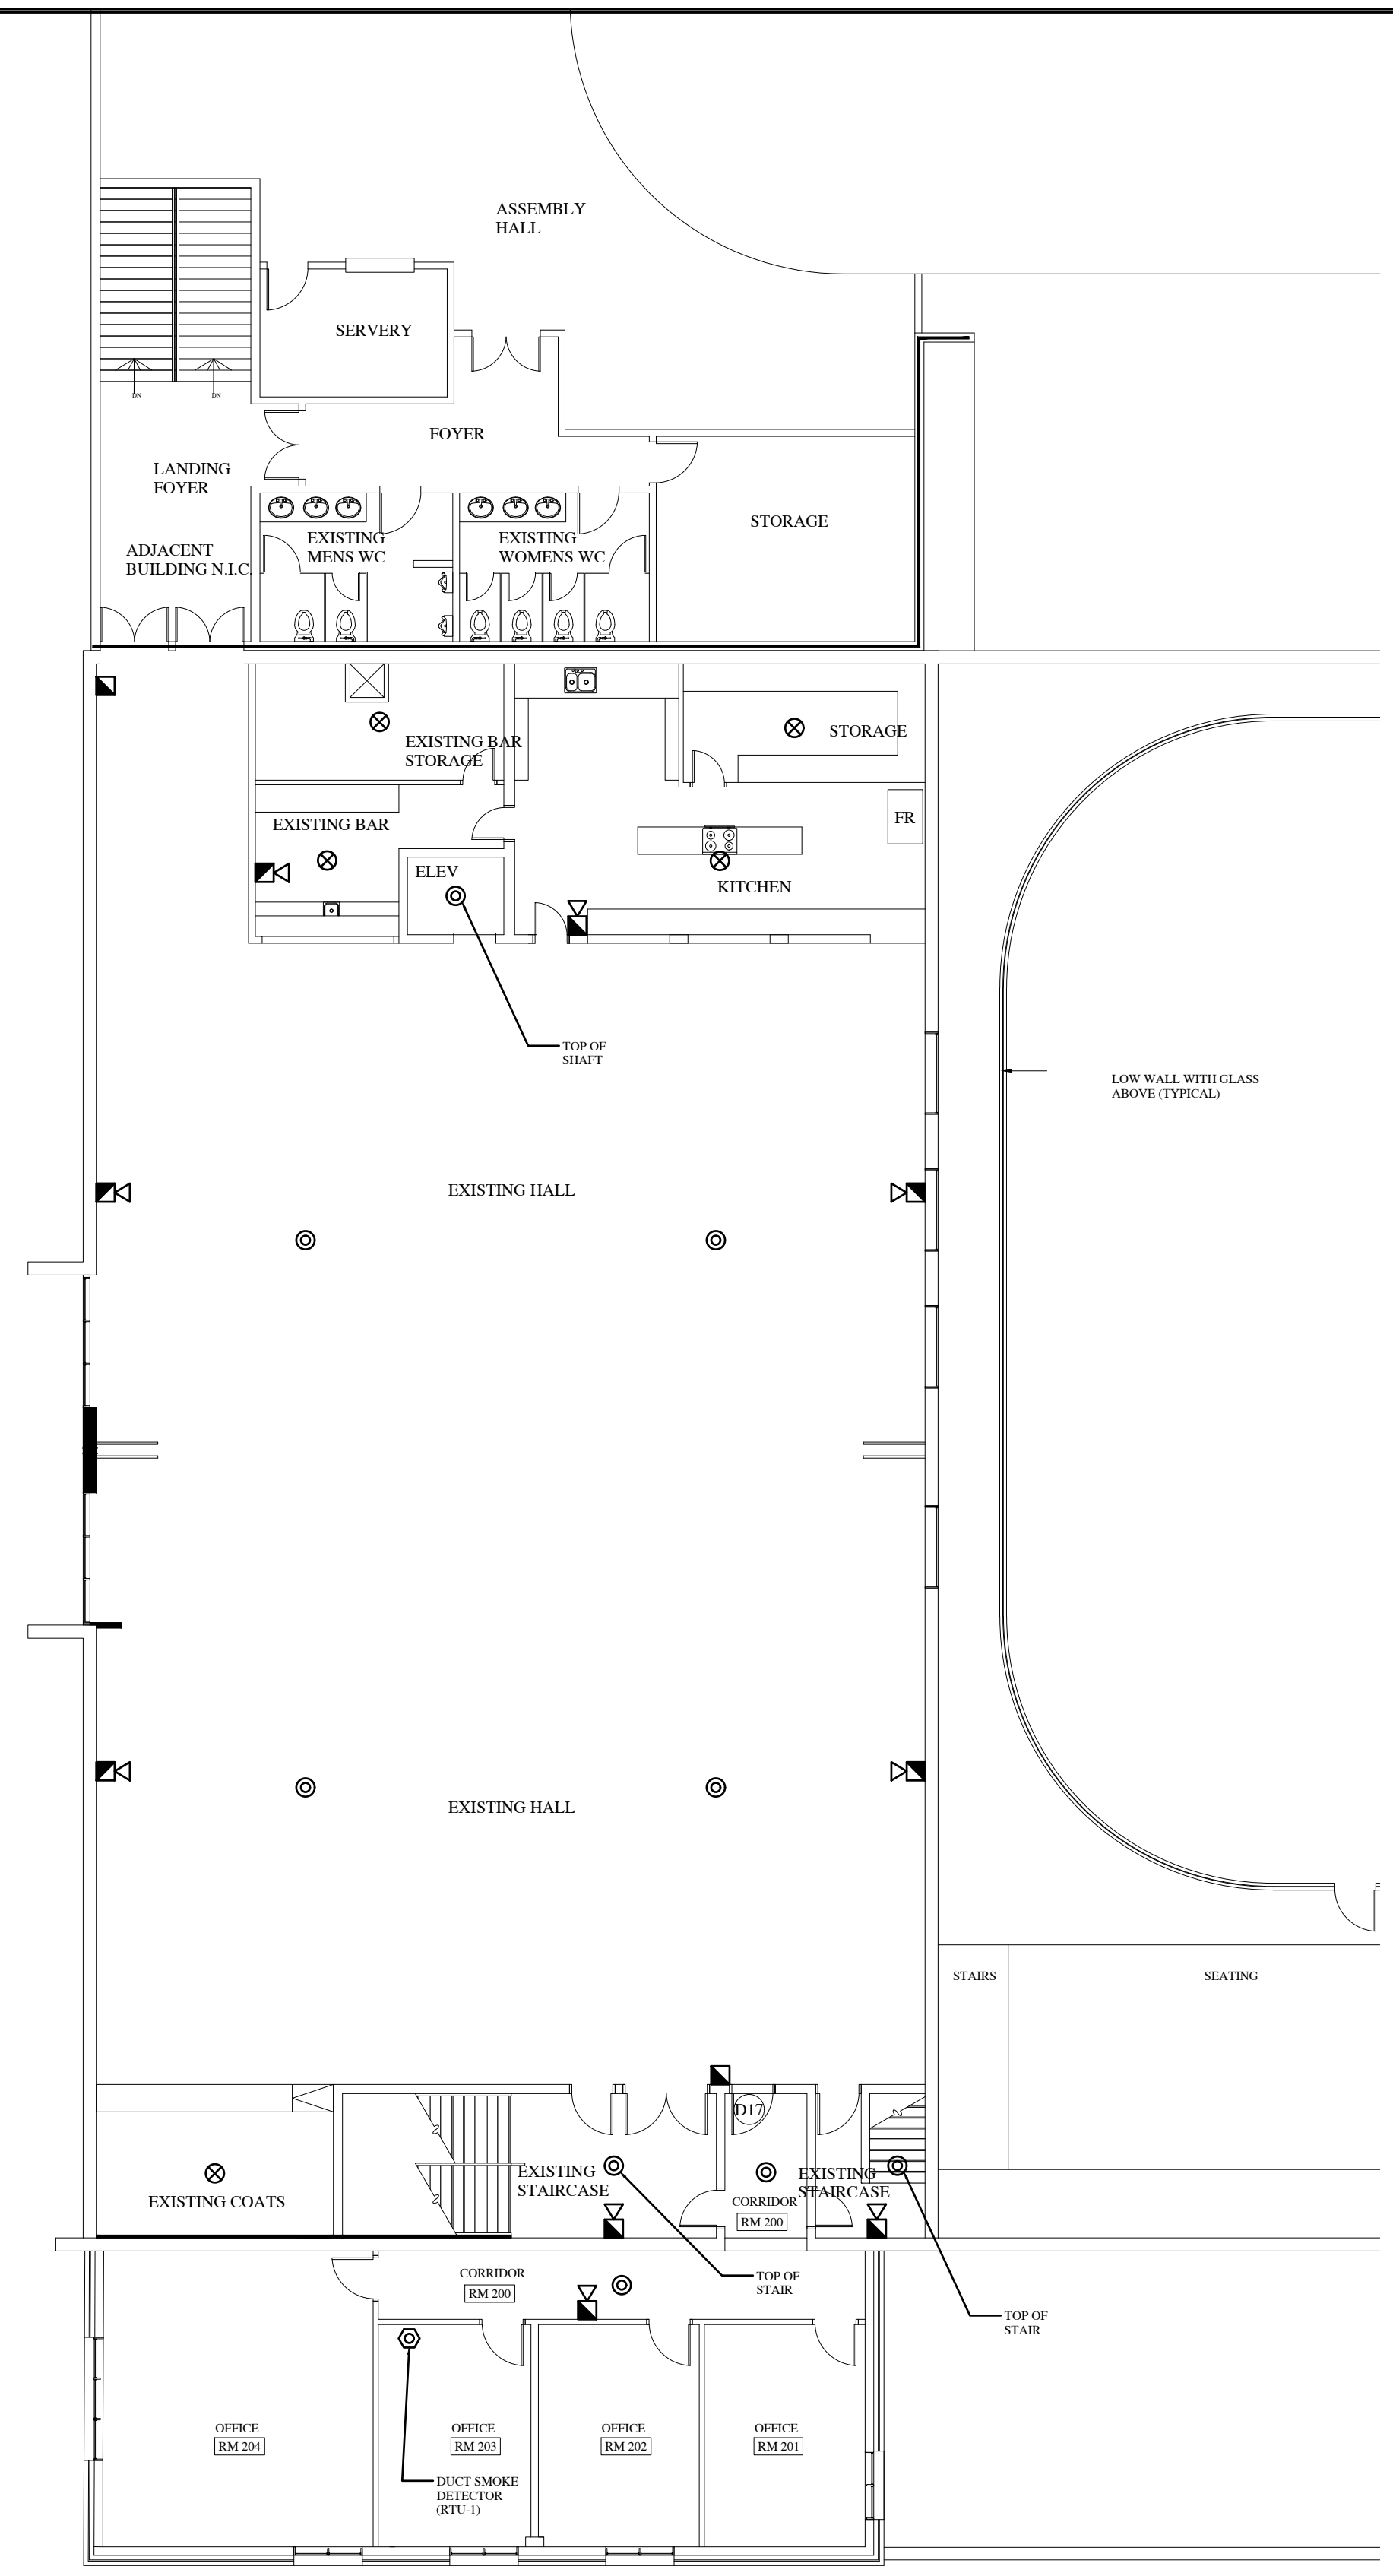

2 SECOND FLOOR PLAN
FA1 SCALE: 3/32" = 1'-0"

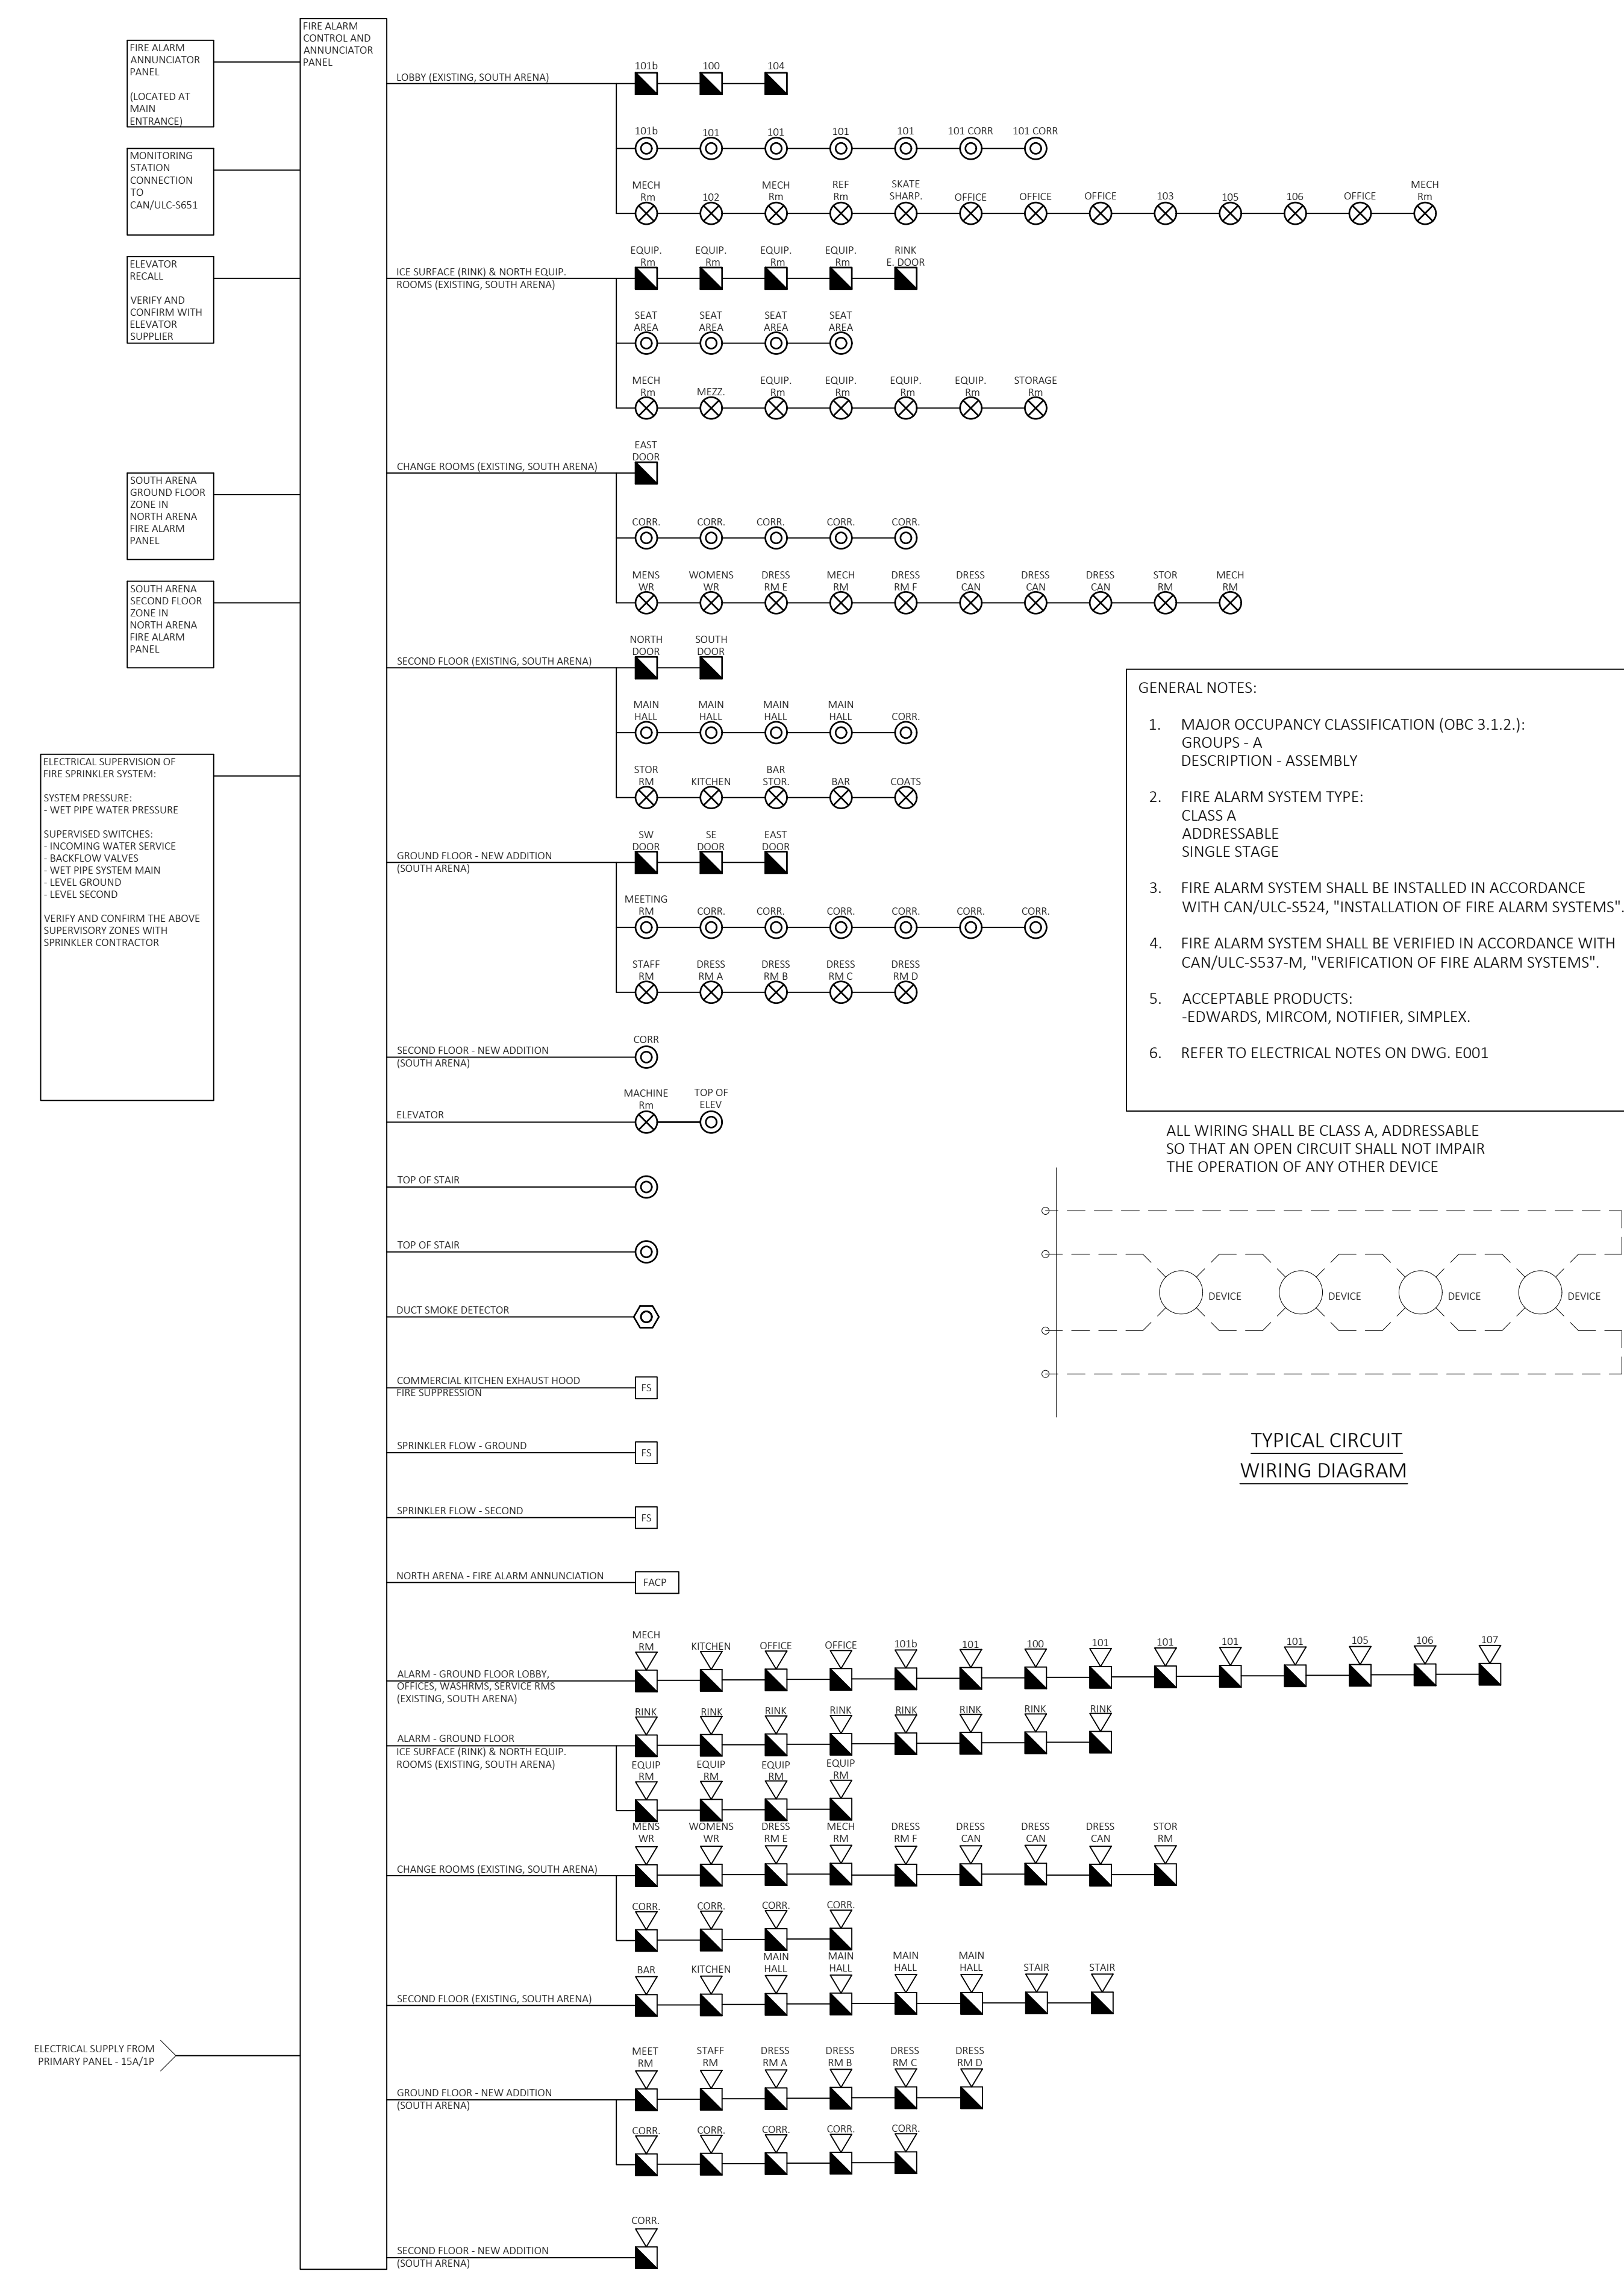

1 FIRE ALARM - SCHEMATIC DIAGRAM
FA1 NTS