

2	2020-12-01	REVISIONS, PER SITE MEETING
1	2020-10-29	REVISIONS, PER SITE DISCUSSION
0	2020-09-22	FOR REVIEW

No. Date Revision

LEGEND:

- ⊗ HEAT DETECTOR
- ⊙ SMOKE DETECTOR
- ⊕ DUCT SMOKE DETECTOR
- PULL STATION
- ▽ FIRE ALARM HORN/STROBE

Client:

LARRY GAINES
ARCHITECT
Almonte, ON

Project:


CARLETON PLACE
ARENA ADDITION
Carleton Place, ON

Drawing:

Fire Alarm System

Design:	M.MORRIS
Drawn:	A.M.
Date:	SEP 2020
Project:	205
Scale:	AS SHOWN

FA2

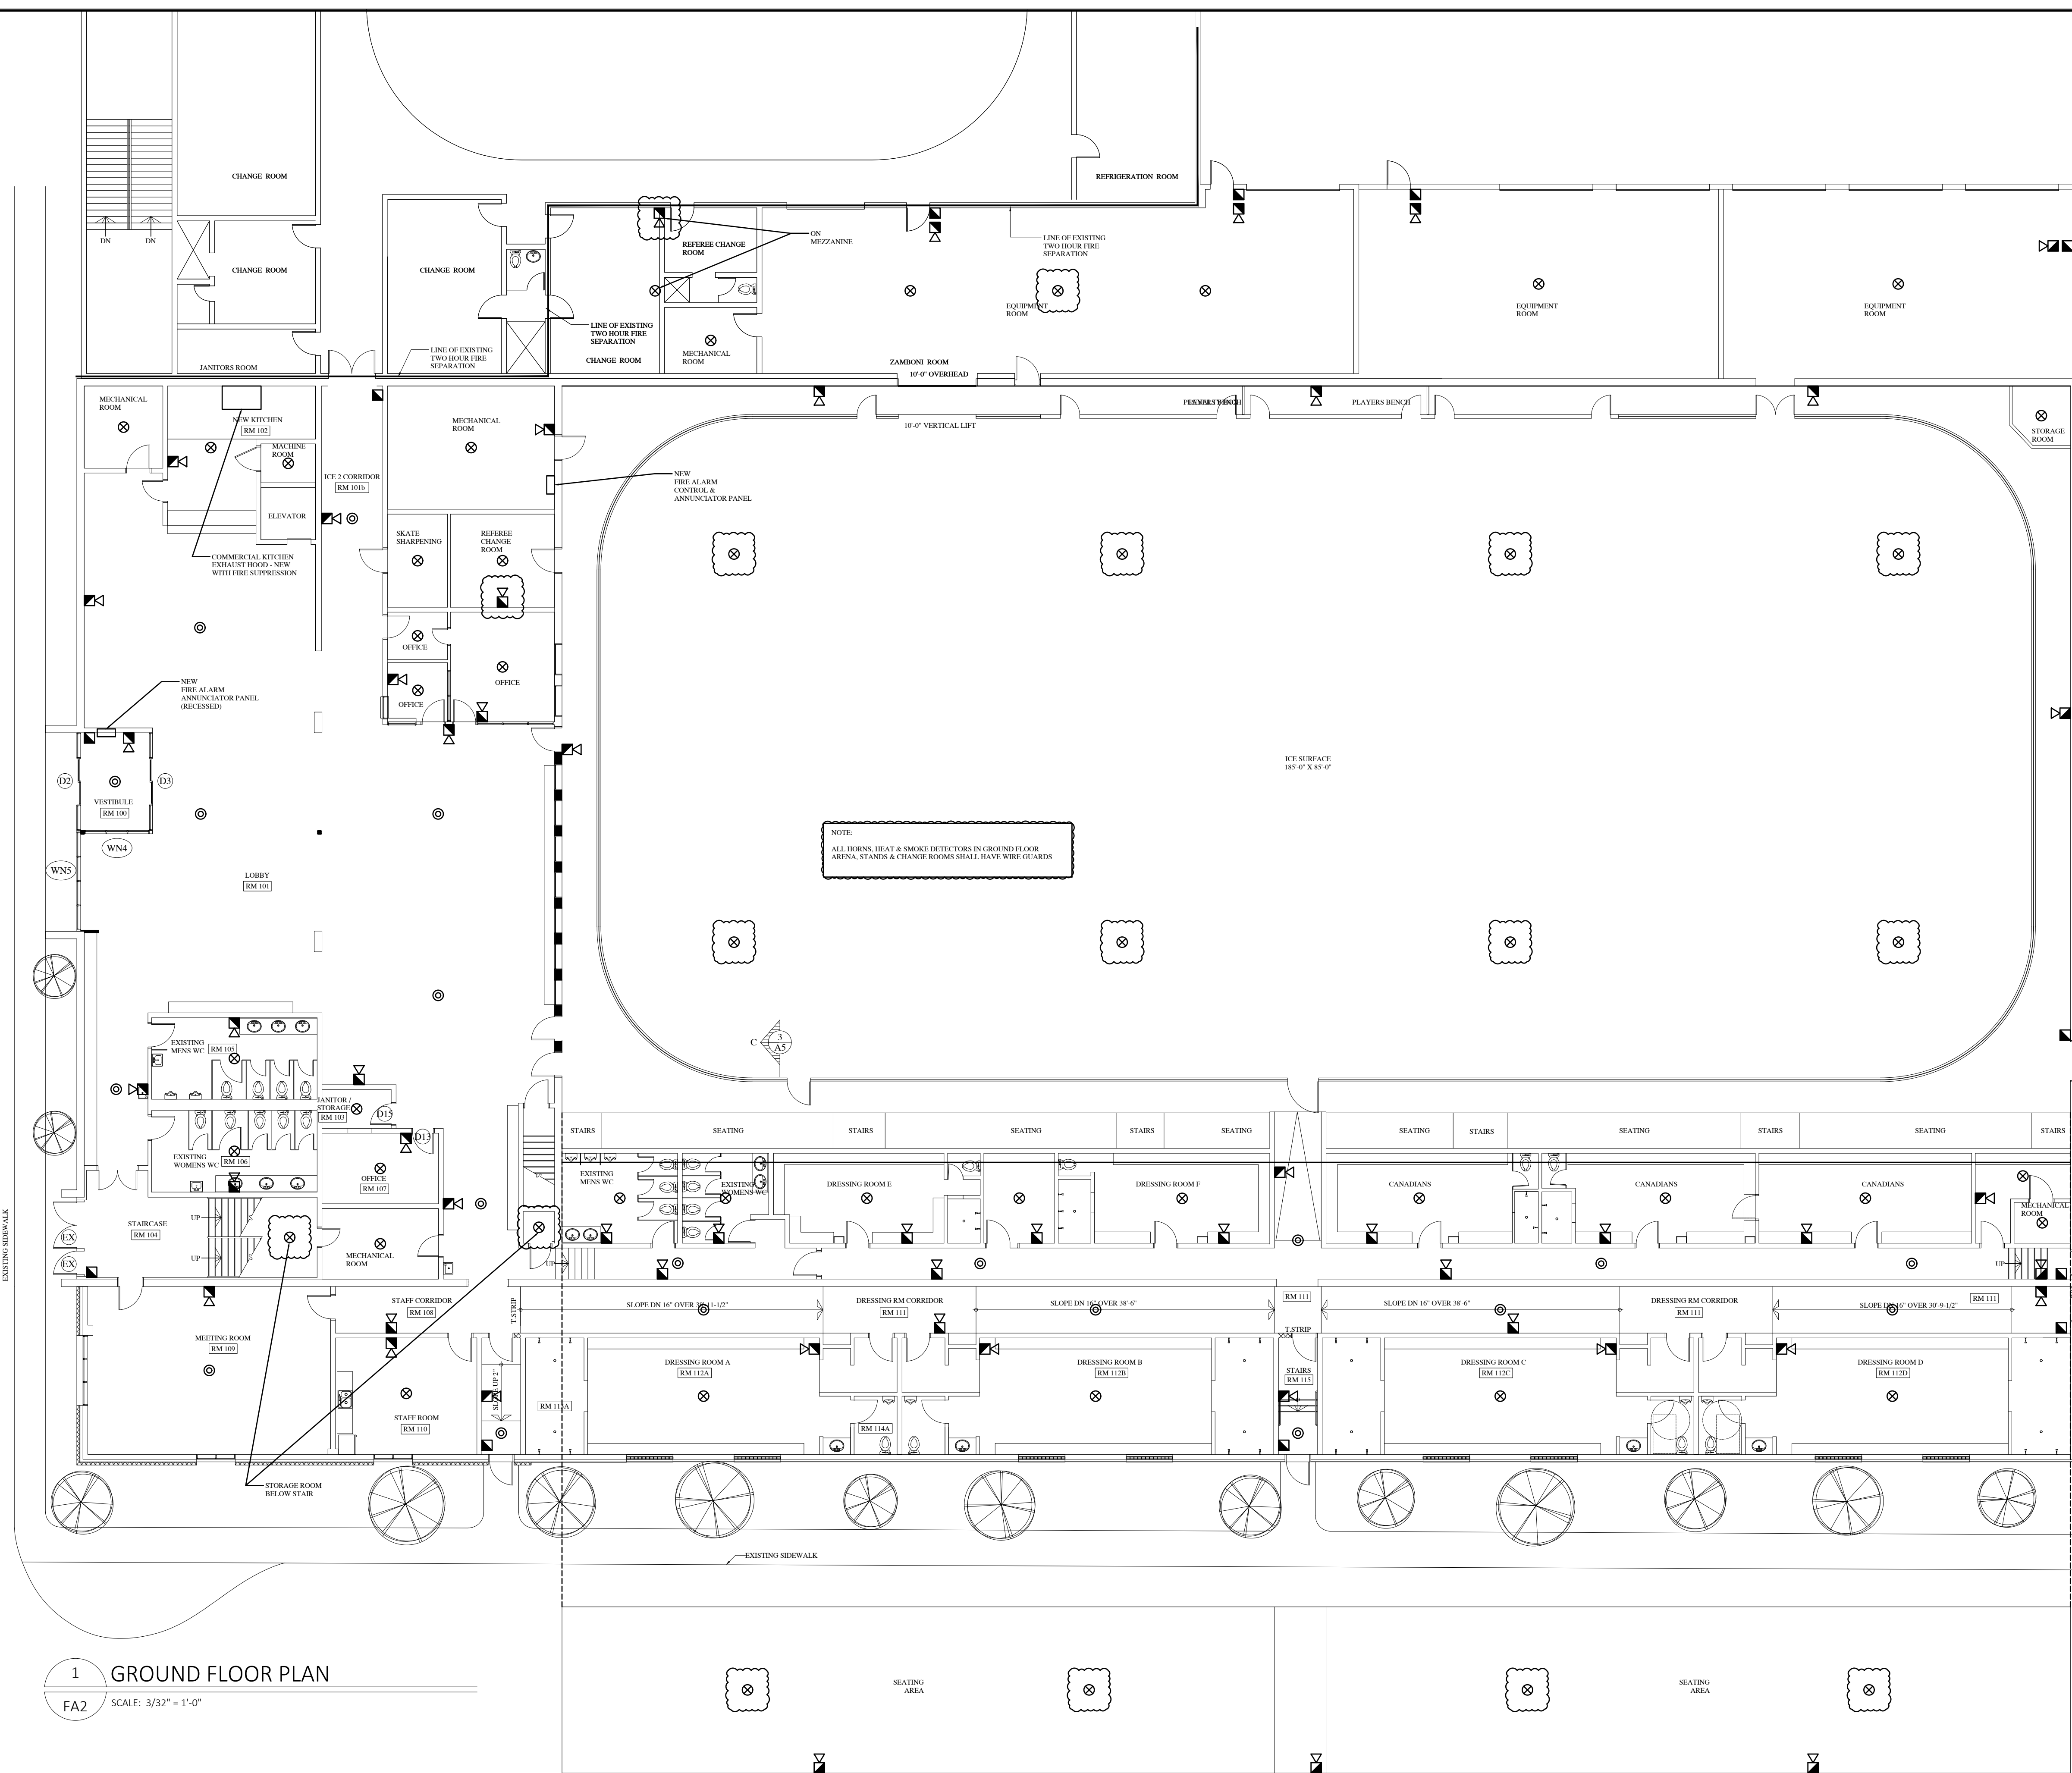

1 GROUND FLOOR PLAN

FA2 SCALE: 3/32" = 1'-0"